


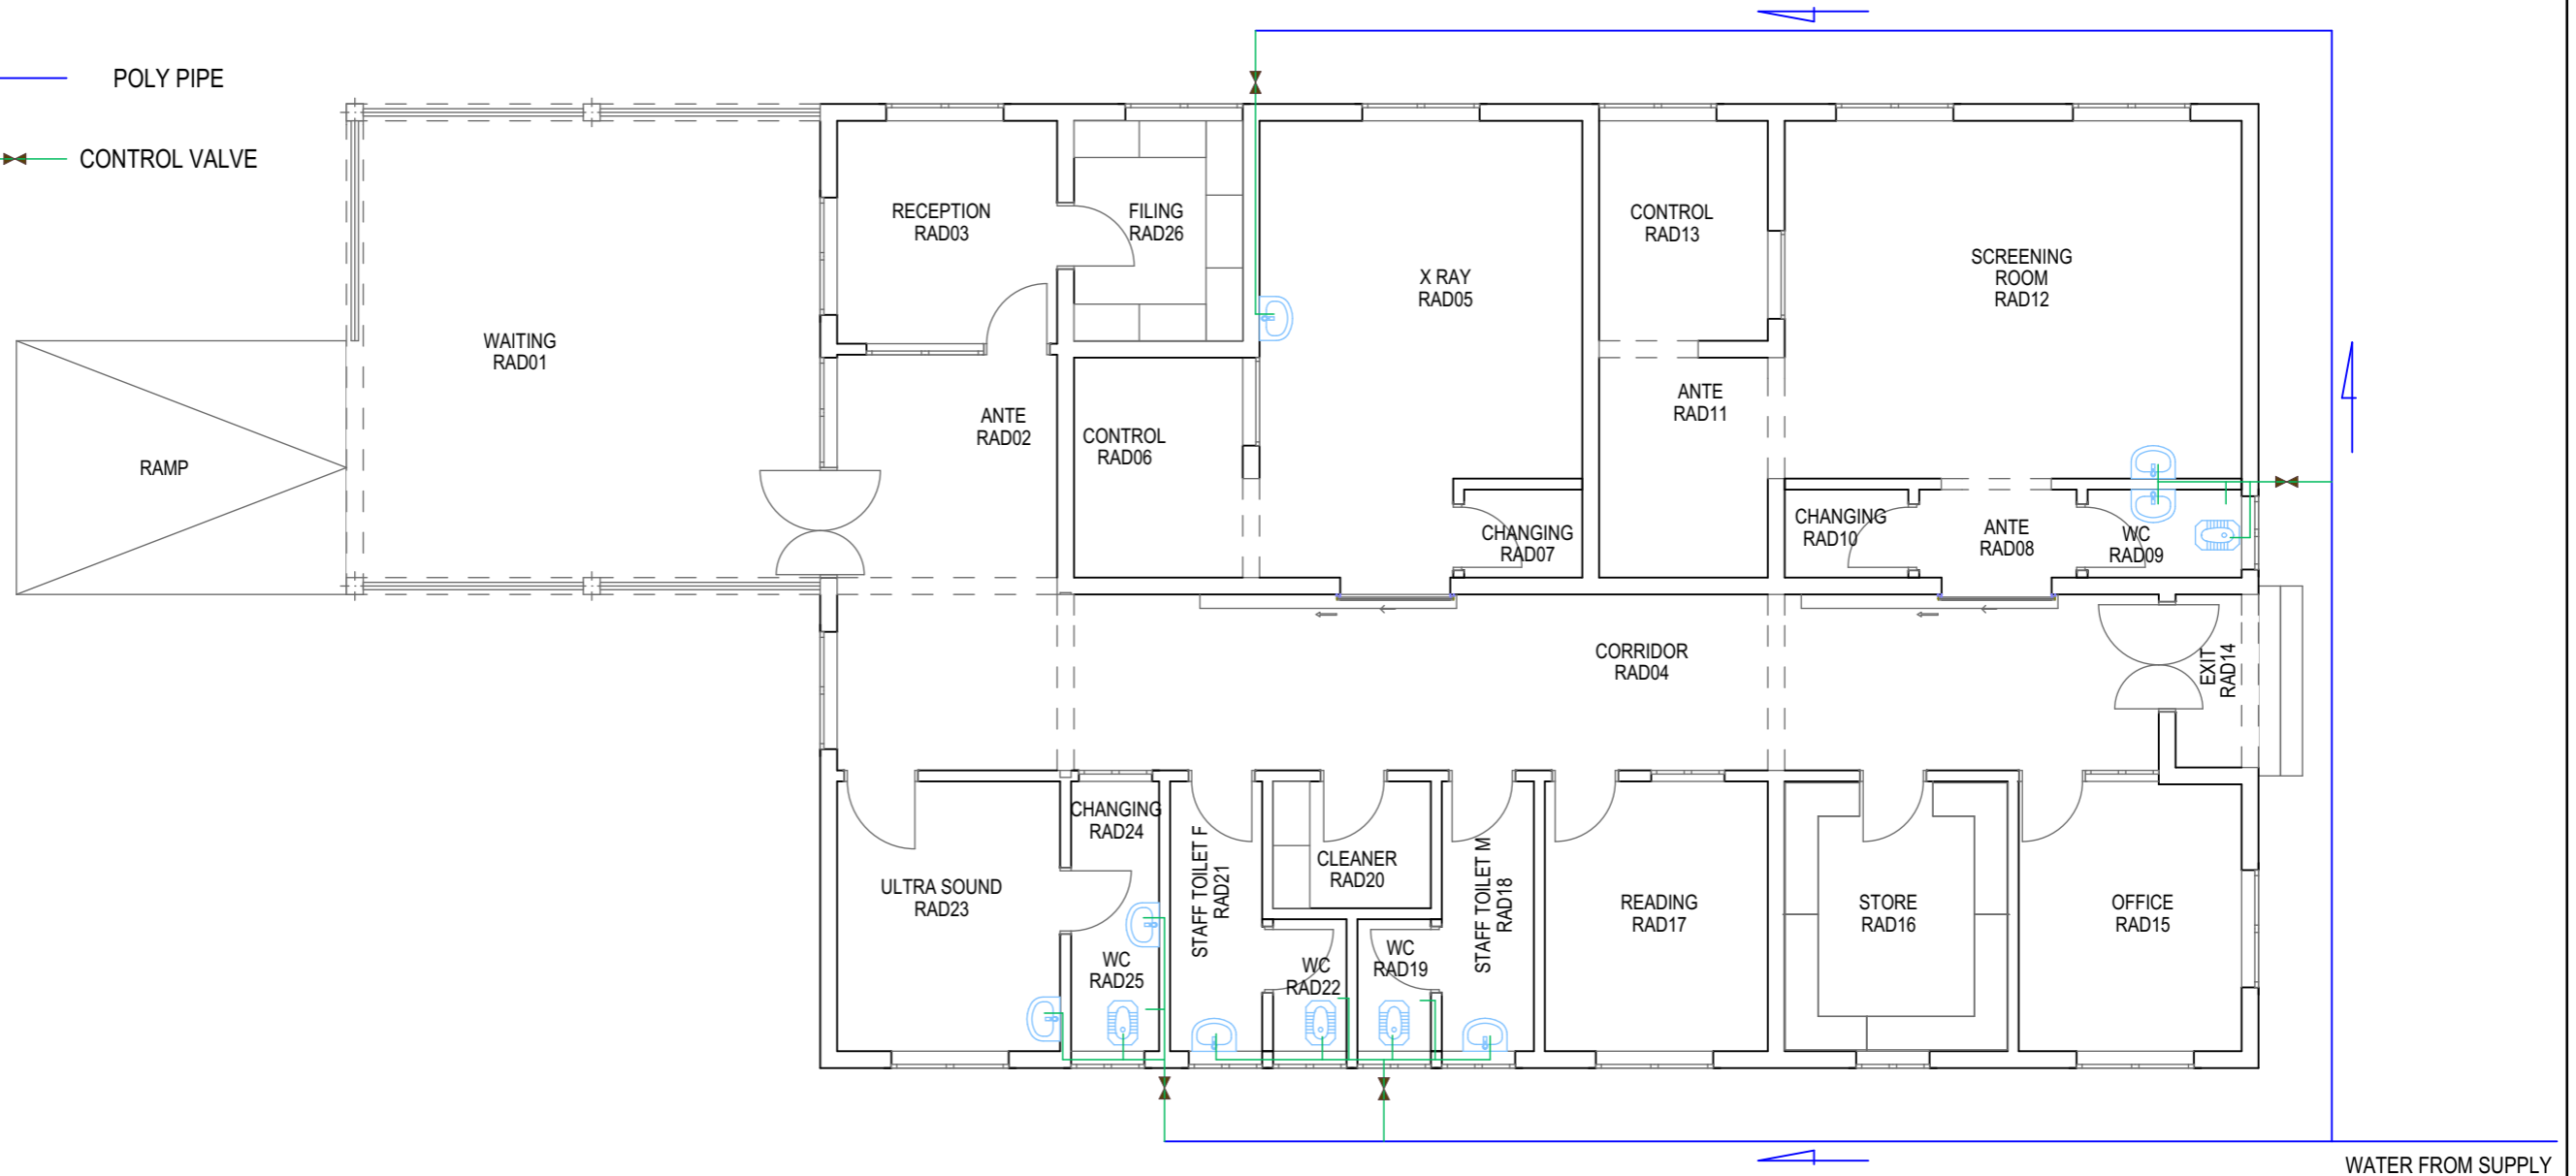


**KEY**

-  IPS PIPE
-  POLY PIPE
-  CONTROL VALVE



**FLOOR PLAN**

Building Section  
 Planning and Policy Department  
 Ministry of Health, Community Development,  
 Gender Elderly and Children.  
 University of Dodoma  
 College of Humanities and Social Science 11th  
 Building, P.O. Box 743,  
 40478 Dodoma

In Collaboration with President's Office, Regional Administration  
 and Local Government.  
 Mkapa Building,  
 P.O. Box 1923,  
 41185 Dodoma

Client  
 PRESIDENT'S OFFICE, REGIONAL ADMINISTRATION AND  
 LOCAL GOVERNMENT, MKAPA BUILDING,  
 P.O. BOX 1923, 41185 DODOMA

Project  
 STANDARD DESIGN FOR COUNCIL LEVEL HOSPITALS IN  
 TANZANIA

Drawing title  
**RADIOLOGY DEPARTMENT  
 WATER LAYOUT**

Project number	RAD/W/01	
Date		May, 2018
Drawn by		AAI
Checked by		ACJ
Scale	1:150	