


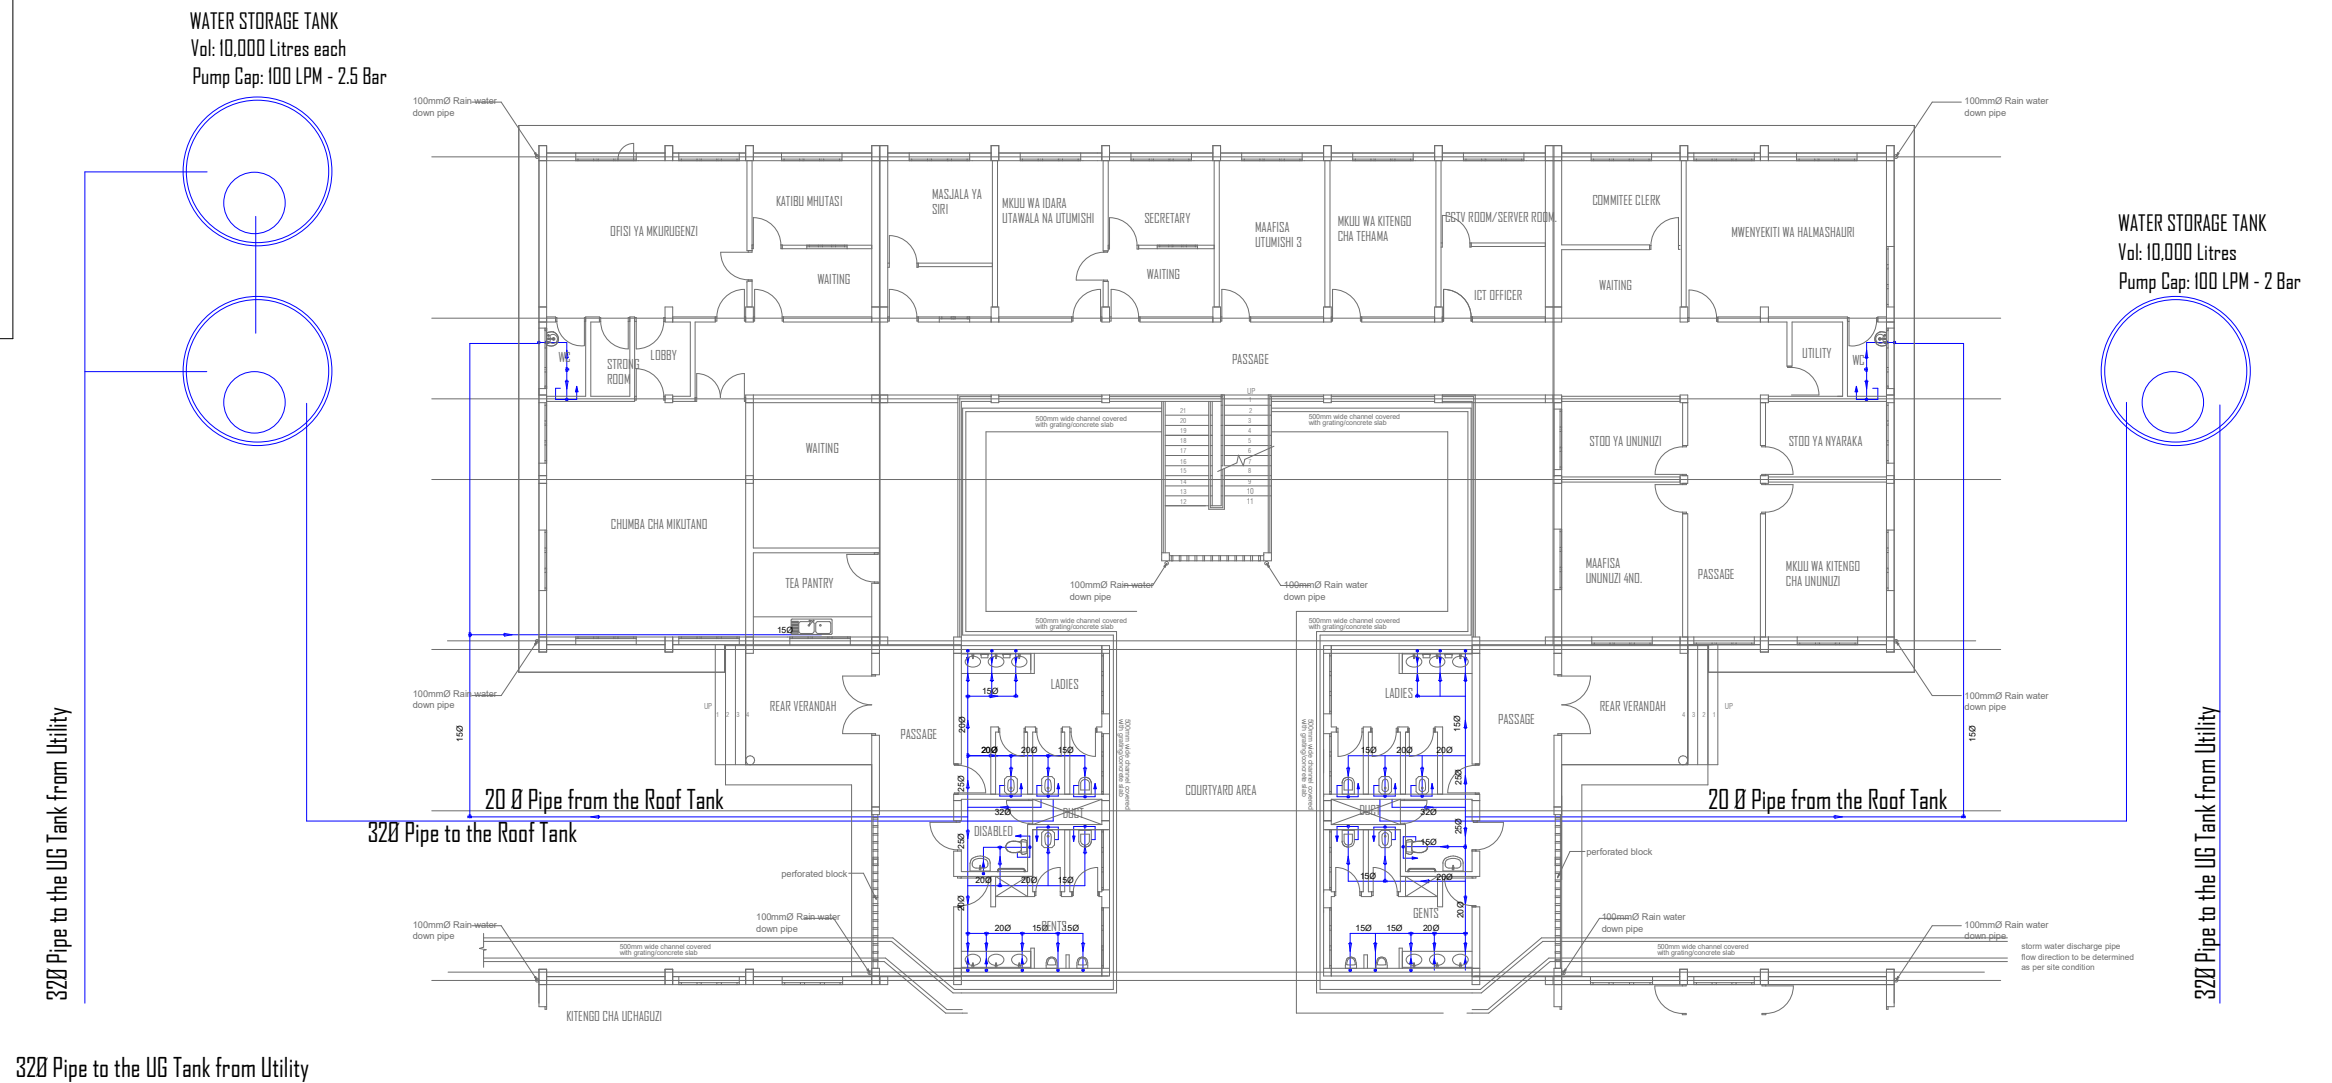

**NOTES AND SYMBOL LEGED**

- 1. All Dimensions are in mm
- 2. ——— Waste/Grey Water Pipe
- 3. ——— Cold Water Pipe
- 4. MH Manhole
- 5. FD Floor Drain
- 6. IL Invert Level
- 7. GT Gully Trap



President's Office, Regional Administration and Local Government.  
Government City - Mtumba,  
TAMISEMI Street P.O. Box 1923,  
41185 Dodoma


**Client**  
PRESIDENT'S OFFICE,  
REGIONAL ADMINISTRATION AND LOCAL GOVERNMENT,  
GOVERNMENT CITY - MTUMBA  
TAMISEMI STREET,P.O. BOX 1923, 41185 DODOMA

**Project**  
PROPOSED STANDARD DRAWINGS FOR DISTRICT COUNCIL OFFICES

<b>Drawing title</b>	
<b>WATER SUPPLY SYSTEM</b>	
<b>Ground Floor Plan</b>	
Project number	<b>W/101B</b>
Date MARCH 2020	
Drawn by HSN	Scale 1:100
Checked by JR	

# NOTES AND SYMBOL LEGED

- 1. All Dimensions are in mm
- 2. ————— Waste/Grey Water Pipe
- 3. ————— Cold Water Pipe
- 4. MH Manhole
- 5. FD Floor Drain
- 6. IL Invert Level
- 7. GT Gully Trap

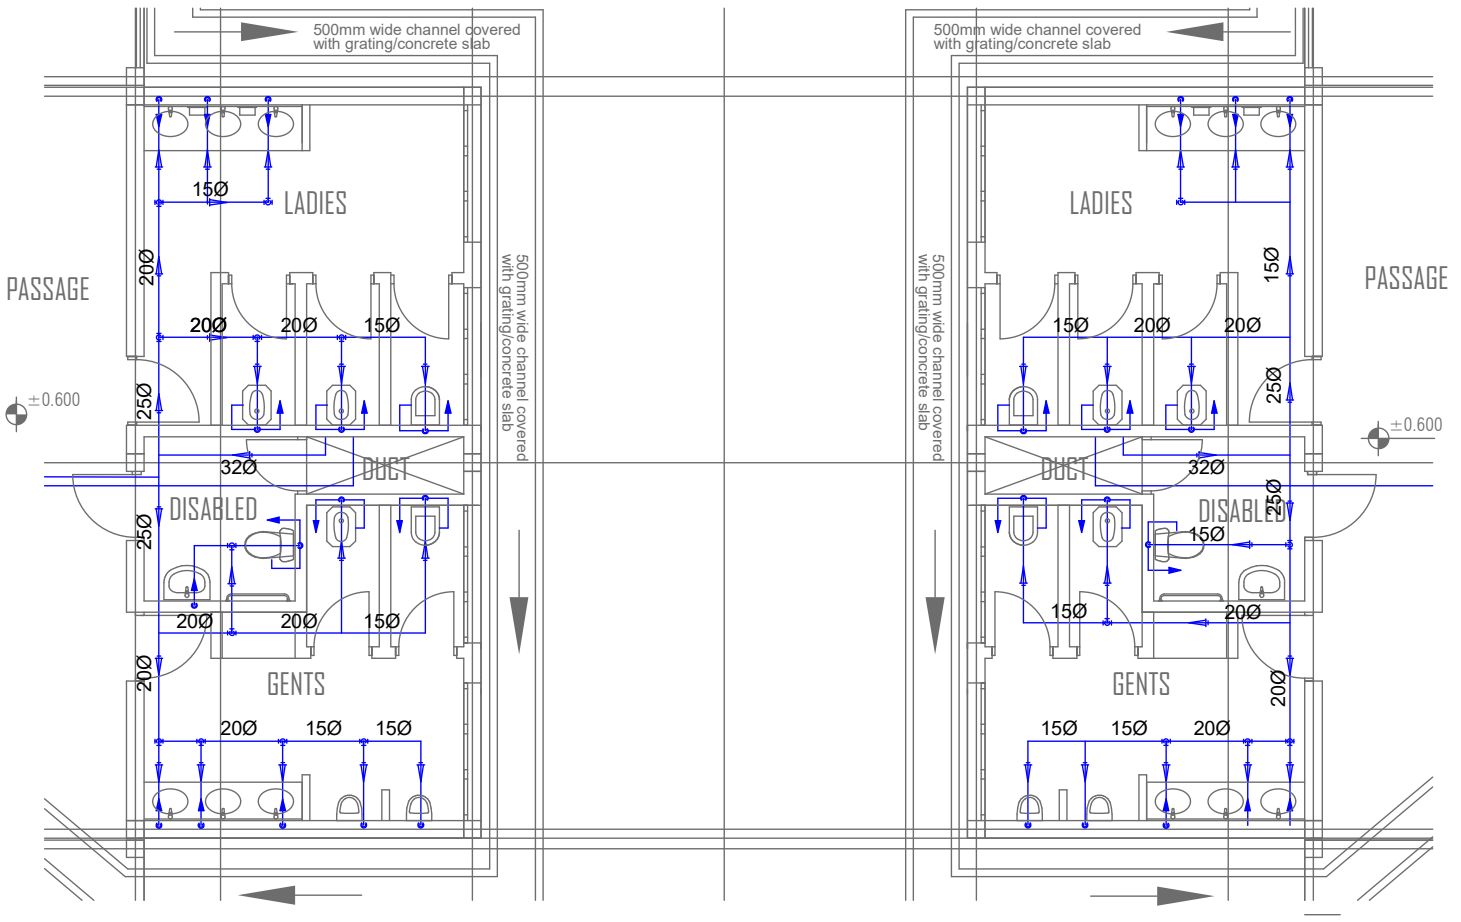

President's Office, Regional Administration and Local Government.  
 Government City - Mtumba,  
 TAMISEMI Street P.O. Box 1923,  
 41185 Dodoma


**Client**  
 PRESIDENT'S OFFICE,  
 REGIONAL ADMINISTRATION AND LOCAL GOVERNMENT,  
 GOVERNMENT CITY - MTUMBA  
 TAMISEMI STREET,P.O. BOX 1923, 41185 DODOMA

**Project**  
 PROPOSED STANDARD DRAWINGS FOR DISTRICT COUNCIL OFFICES

Drawing title		<b>W/101C</b>
<b>DETAILD WATER SUPPLY SYSTEM Ground Floor Plan</b>		
Project number		Scale 1:100
Date	MARCH 2020	
Drawn by	HSN	
Checked by	JR	

### NOTES AND SYMBOL LEGED

1. All Dimensions are in mm
2. ——— Waste/Grey Water Pipe
3. ——— Cold Water Pipe
4. MH Manhole
5. FD Floor Drain
6. IL Invert Level
7. GT Gully Trap

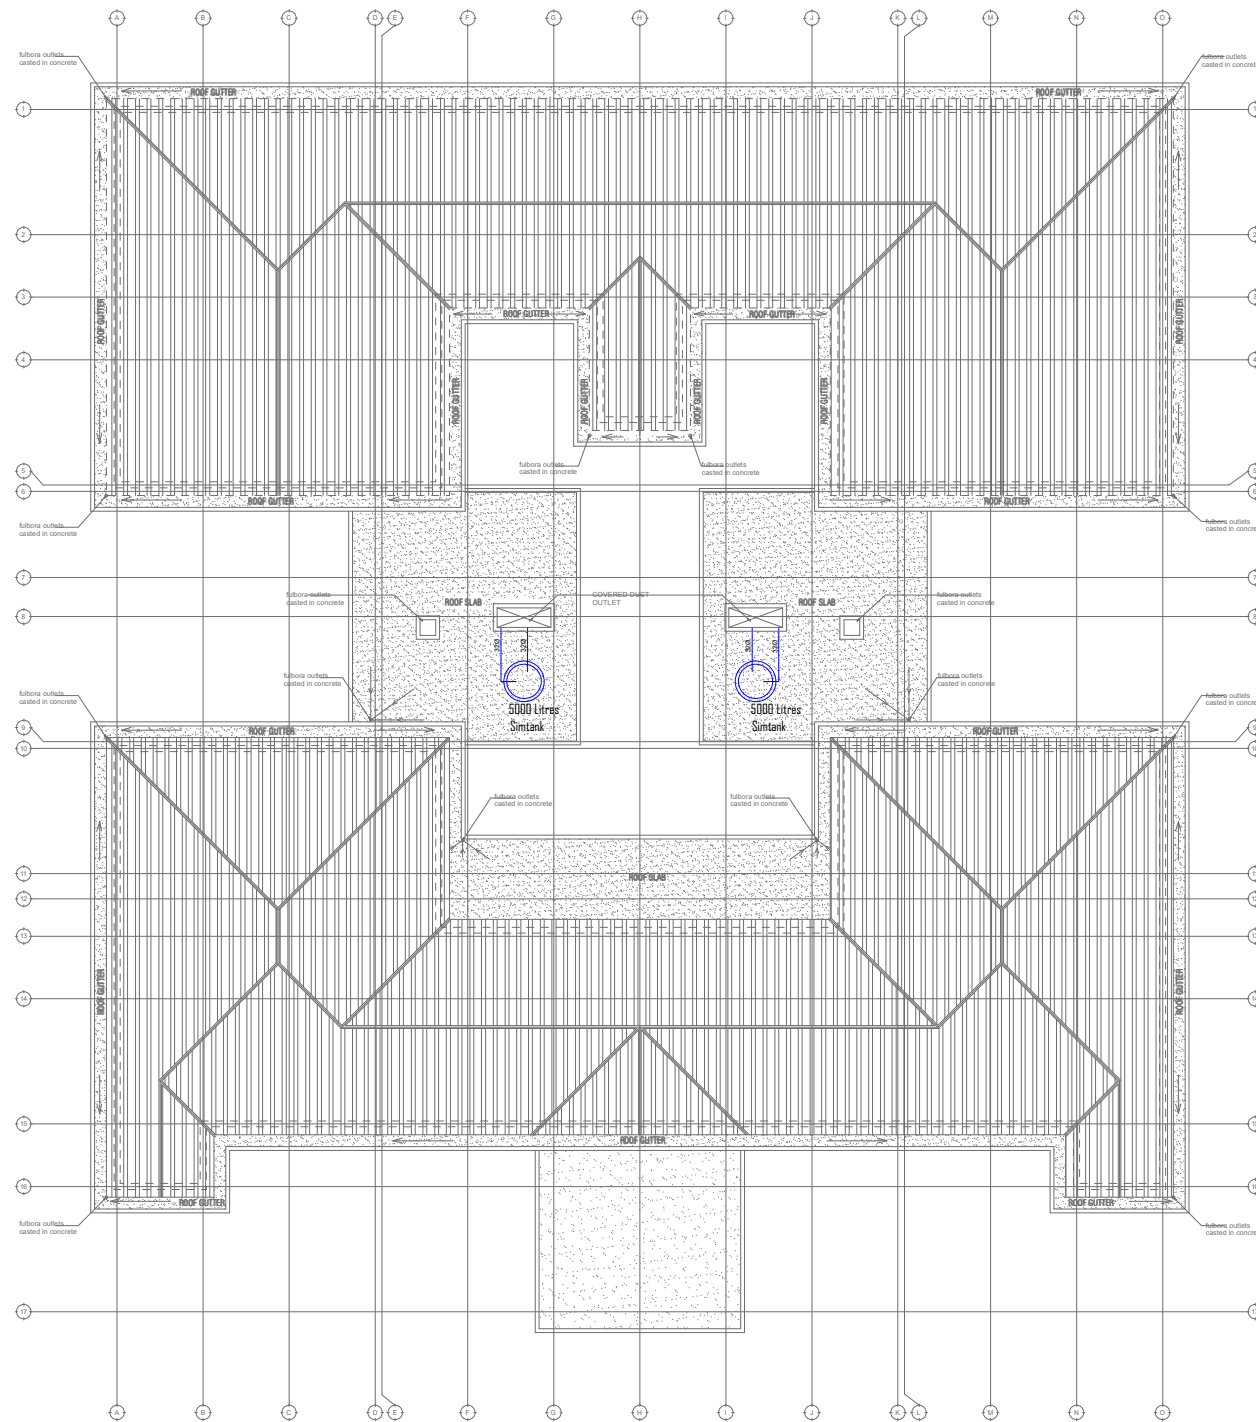

**ROOF PLAN**

President's Office, Regional Administration  
and Local Government.  
Government City - Mtumba,  
TAMISEMI Street P.O. Box 1923,  
41185 Dodoma



**Client**  
PRESIDENT'S OFFICE,  
REGIONAL ADMINISTRATION AND LOCAL GOVERNMENT,  
GOVERNMENT CITY - MTUMBA  
TAMISEMI STREET,P.O. BOX 1923, 41185 DODOMA


**Project**  
PROPOSED STANDARD DRAWINGS FOR DISTRICT COUNCILS OFFICES

Drawing title  
**WATER SUPPLY SYSTEM**  
Roof Plan

Project number	<b>W/102</b>
Date MARCH 2020	
Drawn by IAS	
Checked by JR	
Scale 1:100	

## NOTES AND SYMBOL LEGED

1. All Dimensions are in mm
2.  Waste/Grey Water Pipe
3.  Cold Water Pipe
4. MH Manhole
5. FD Floor Drain
6. IL Invert Level
7. GT Gully Trap

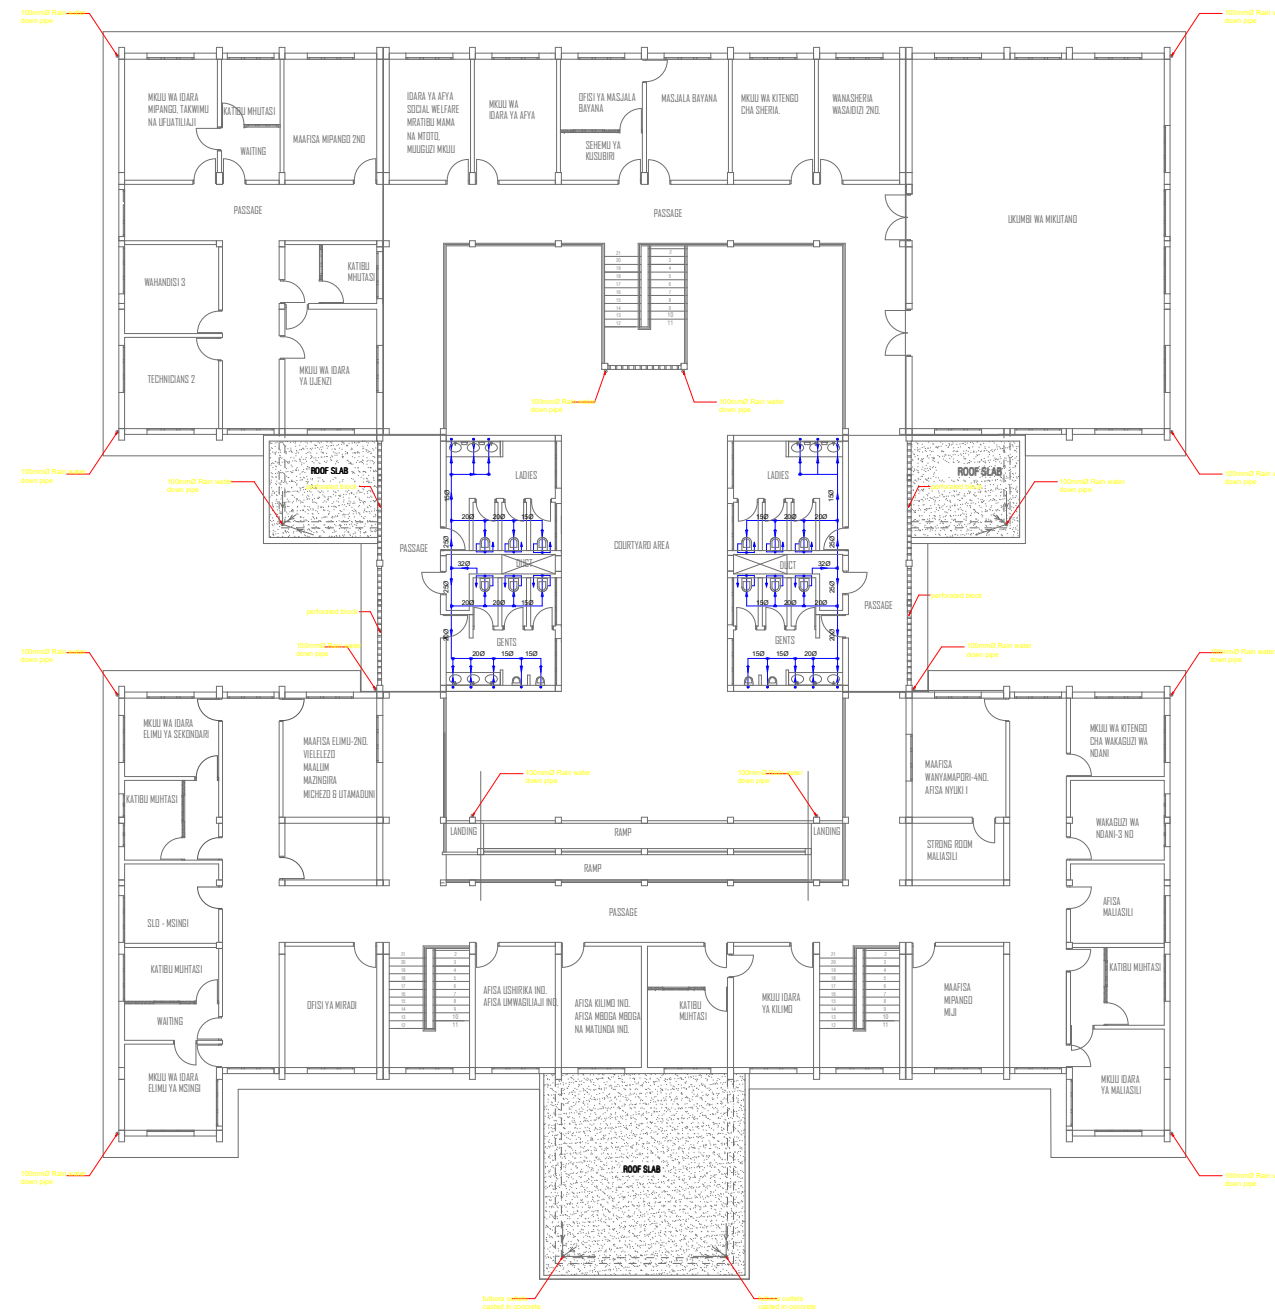

**FIRST FLOOR PLAN**

President's Office, Regional Administration  
and Local Government.  
Government City - Mtumba,  
TAMISEMI Street P.O. Box 1923,  
41185 Dodoma

**Client**

PRESIDENT'S OFFICE,  
REGIONAL ADMINISTRATION AND LOCAL GOVERNMENT,  
GOVERNMENT CITY - MTUMBA  
TAMISEMI STREET,P.O. BOX 1923, 41185 DODOMA

**Project**

PROPOSED STANDARD DRAWINGS FOR DISTRICT COUNCIL OFFICES

**Drawing title**

**WATER SUPPLY SYSTEM**  
First Floor Plan

Project number


Date MARCH 2020

Drawn by HSN

Checked by JR

**W/103A**

Scale 1:100

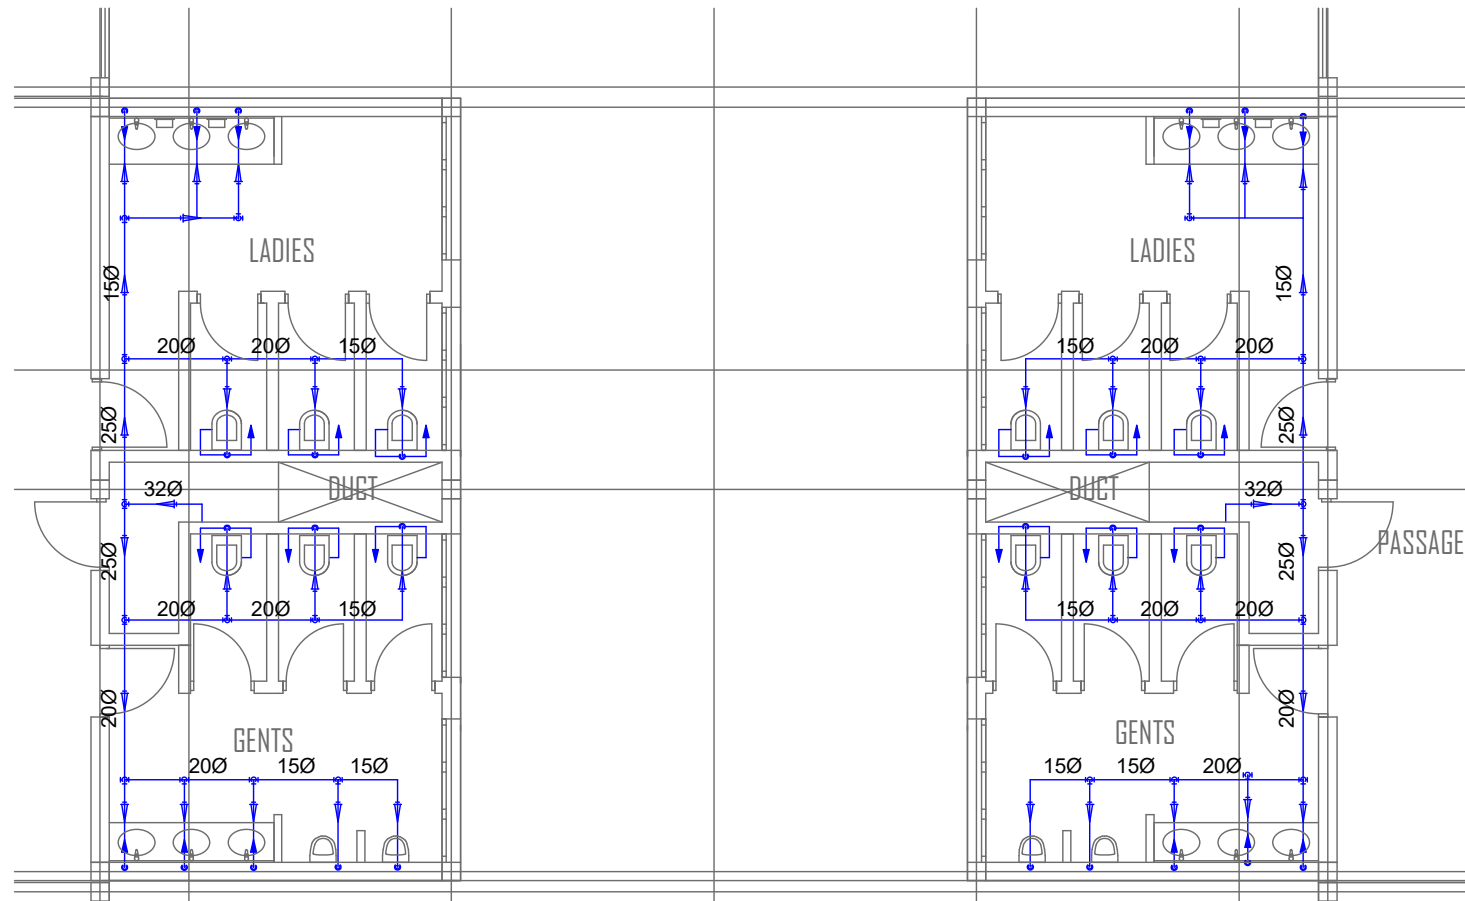

**NOTES AND SYMBOL LEGED**

- 1. All Dimensions are in mm
- 2. ——— Waste/Grey Water Pipe
- 3. ——— Cold Water Pipe
- 4. MH Manhole
- 5. FD Floor Drain
- 6. IL Invert Level
- 7. GT Gully Trap

**PARTIAL FIRST FLOOR PLAN**

President's Office, Regional Administration  
and Local Government.  
Government City - Mtumba,  
TAMISEMI Street P.O. Box 1923,  
41185 Dodoma

**Client**  
PRESIDENT'S OFFICE,  
REGIONAL ADMINISTRATION AND LOCAL GOVERNMENT,  
GOVERNMENT CITY - MTUMBA  
TAMISEMI STREET,P.O. BOX 1923, 41185 DODOMA

**Project**


PROPOSED STANDARD DRAWINGS FOR DISTRICT COUNCIL OFFICES

Drawing title  
**DETAILED WATER SUPPLY  
SYSTEM**  
First Floor Plan

Project number	<b>W/103B</b>
Date MARCH 2020	
Drawn by HSN	Scale 1:100
Checked by JR	

## NOTES AND SYMBOL LEGED

1. All Dimensions are in mm
2. ——— Waste/Grey Water Pipe
3. ——— Cold Water Pipe
4. MH Manhole
5. FD Floor Drain
6. IL Invert Level
7. GT Gully Trap

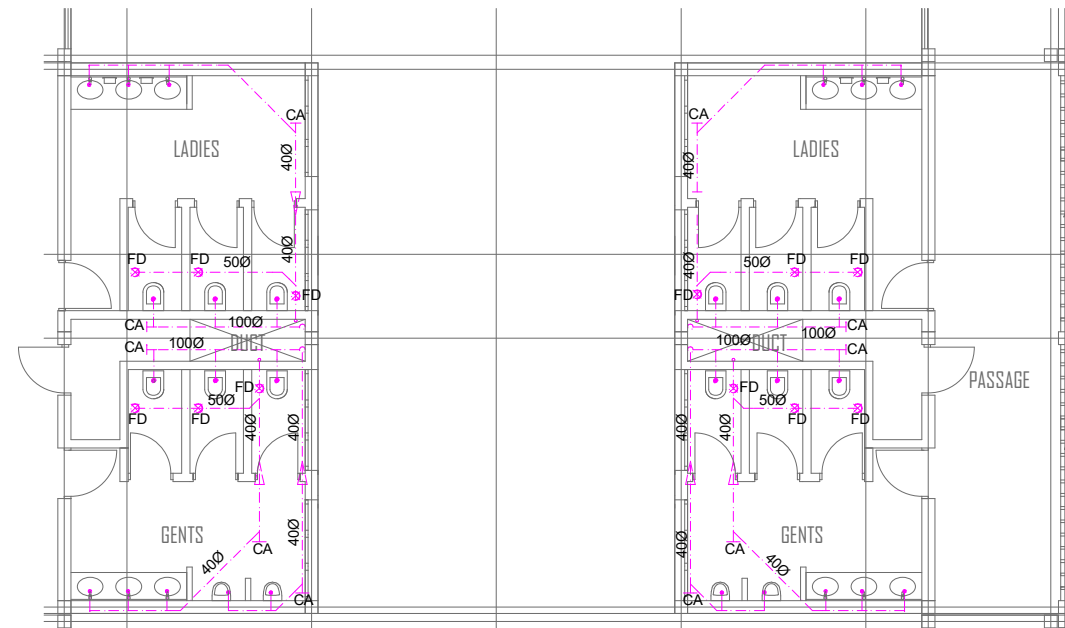

## PARTIAL FIRST FLOOR PLAN

President's Office, Regional Administration  
and Local Government.  
Government City - Mtumba,  
TAMISEMI Street P.O. Box 1923,  
41185 Dodoma

### Client

PRESIDENT'S OFFICE,  
REGIONAL ADMINISTRATION AND LOCAL GOVERNMENT,  
GOVERNMENT CITY - MTUMBA  
TAMISEMI STREET, P.O. BOX 1923, 41185 DODOMA

### Project

PROPOSED STANDARD DRAWINGS FOR DISTRICT COUNCIL OFFICES

Drawing title

**DRAINAGE SYSTEM**  
First Floor Plan

Project number

Date MARCH 2020

Drawn by HSN



Checked by JR


**D/104B**

Scale 1:100



## NOTES AND SYMBOL LEGED

1. All Dimensions are in mm
2.  Waste/Grey Water Pipe
3.  Cold Water Pipe
4. MH Manhole
5. FD Floor Drain
6. IL Invert Level
7. GT Gully Trap

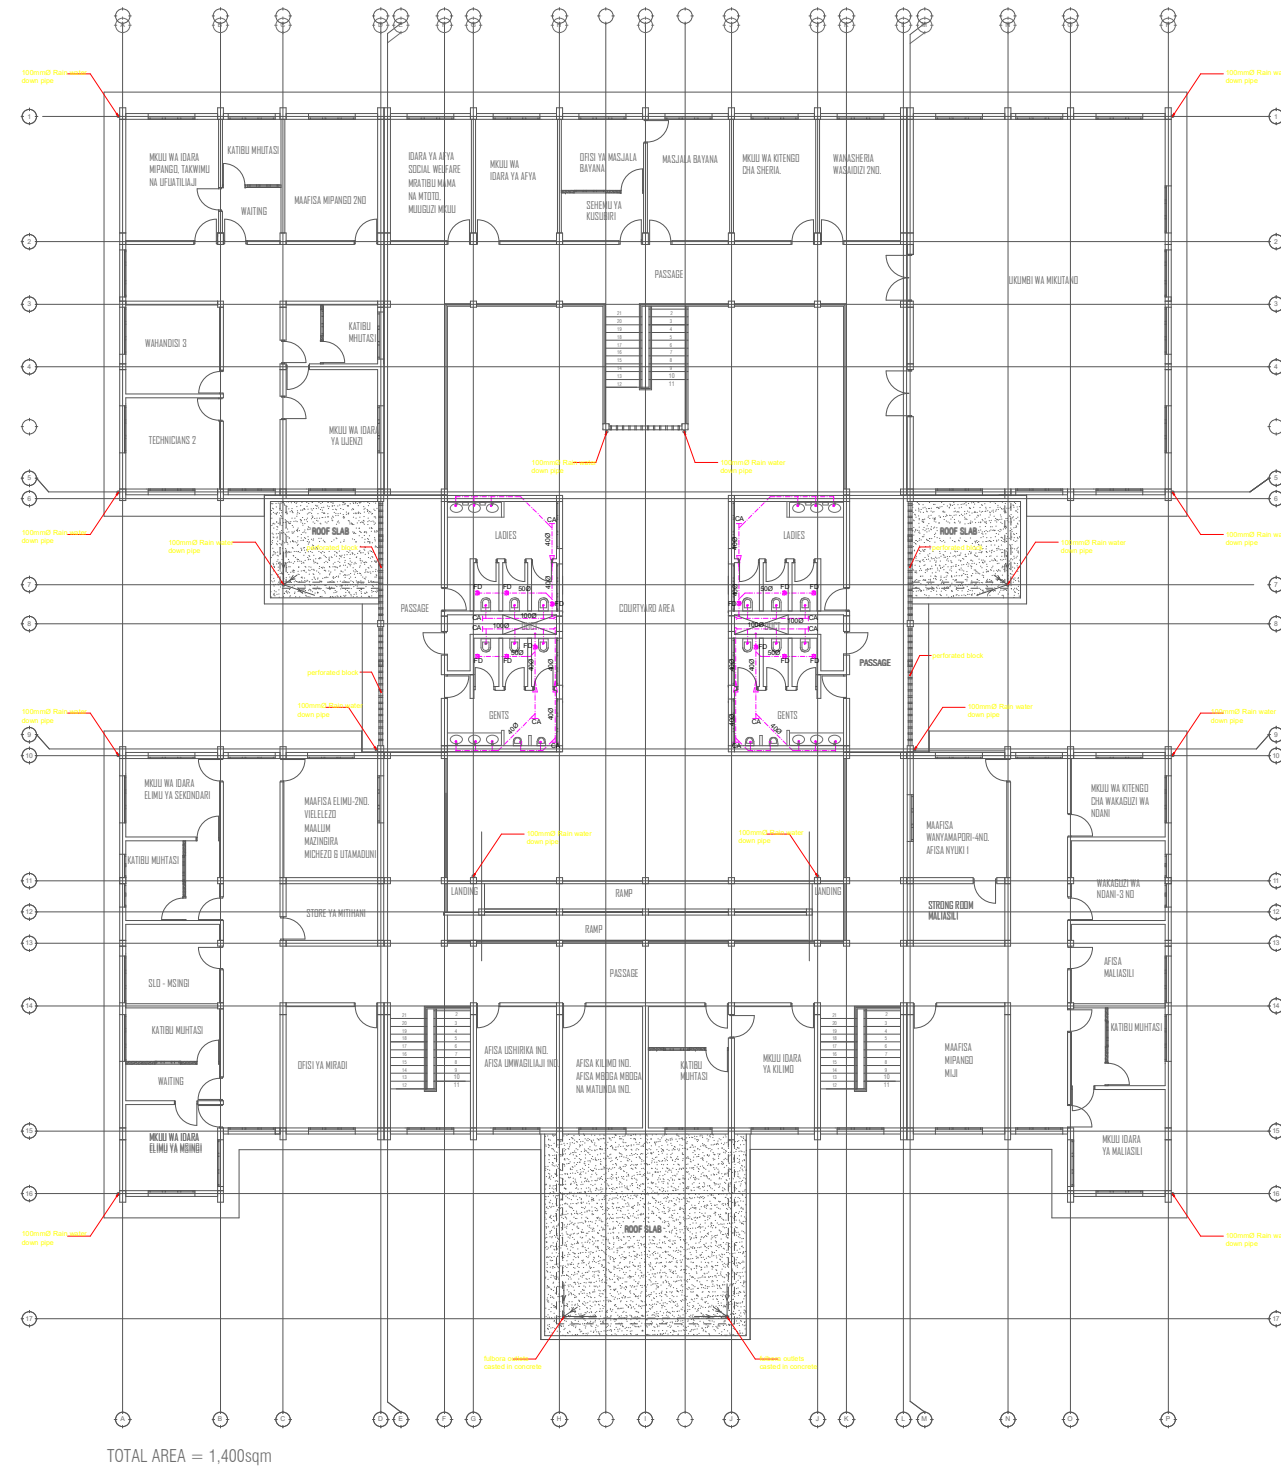

## FIRST FLOOR PLAN

President's Office, Regional Administration  
and Local Government.  
Government City - Mtumba,  
TAMISEMI Street P.O. Box 1923,  
41185 Dodoma

### Client

PRESIDENT'S OFFICE,  
REGIONAL ADMINISTRATION AND LOCAL GOVERNMENT,  
GOVERNMENT CITY - MTUMBA  
TAMISEMI STREET, P.O. BOX 1923, 41185 DODOMA

### Project

PROPOSED STANDARD DRAWINGS FOR DISTRICT COUNCIL OFFICES

### Drawing title

**DRAINAGE SYSTEM**  
First Floor Plan

Project number

Date MARCH 2020

Drawn by HSN

Checked by JR


**D/104A**

Scale 1:100



**NOTES AND SYMBOL LEGED**

1. All Dimensions are in mm
2. ——— Waste/Grey Water Pipe
3. ——— Cold Water Pipe
4. MH Manhole
5. FD Floor Drain
6. IL Invert Level
7. GT Gully Trap

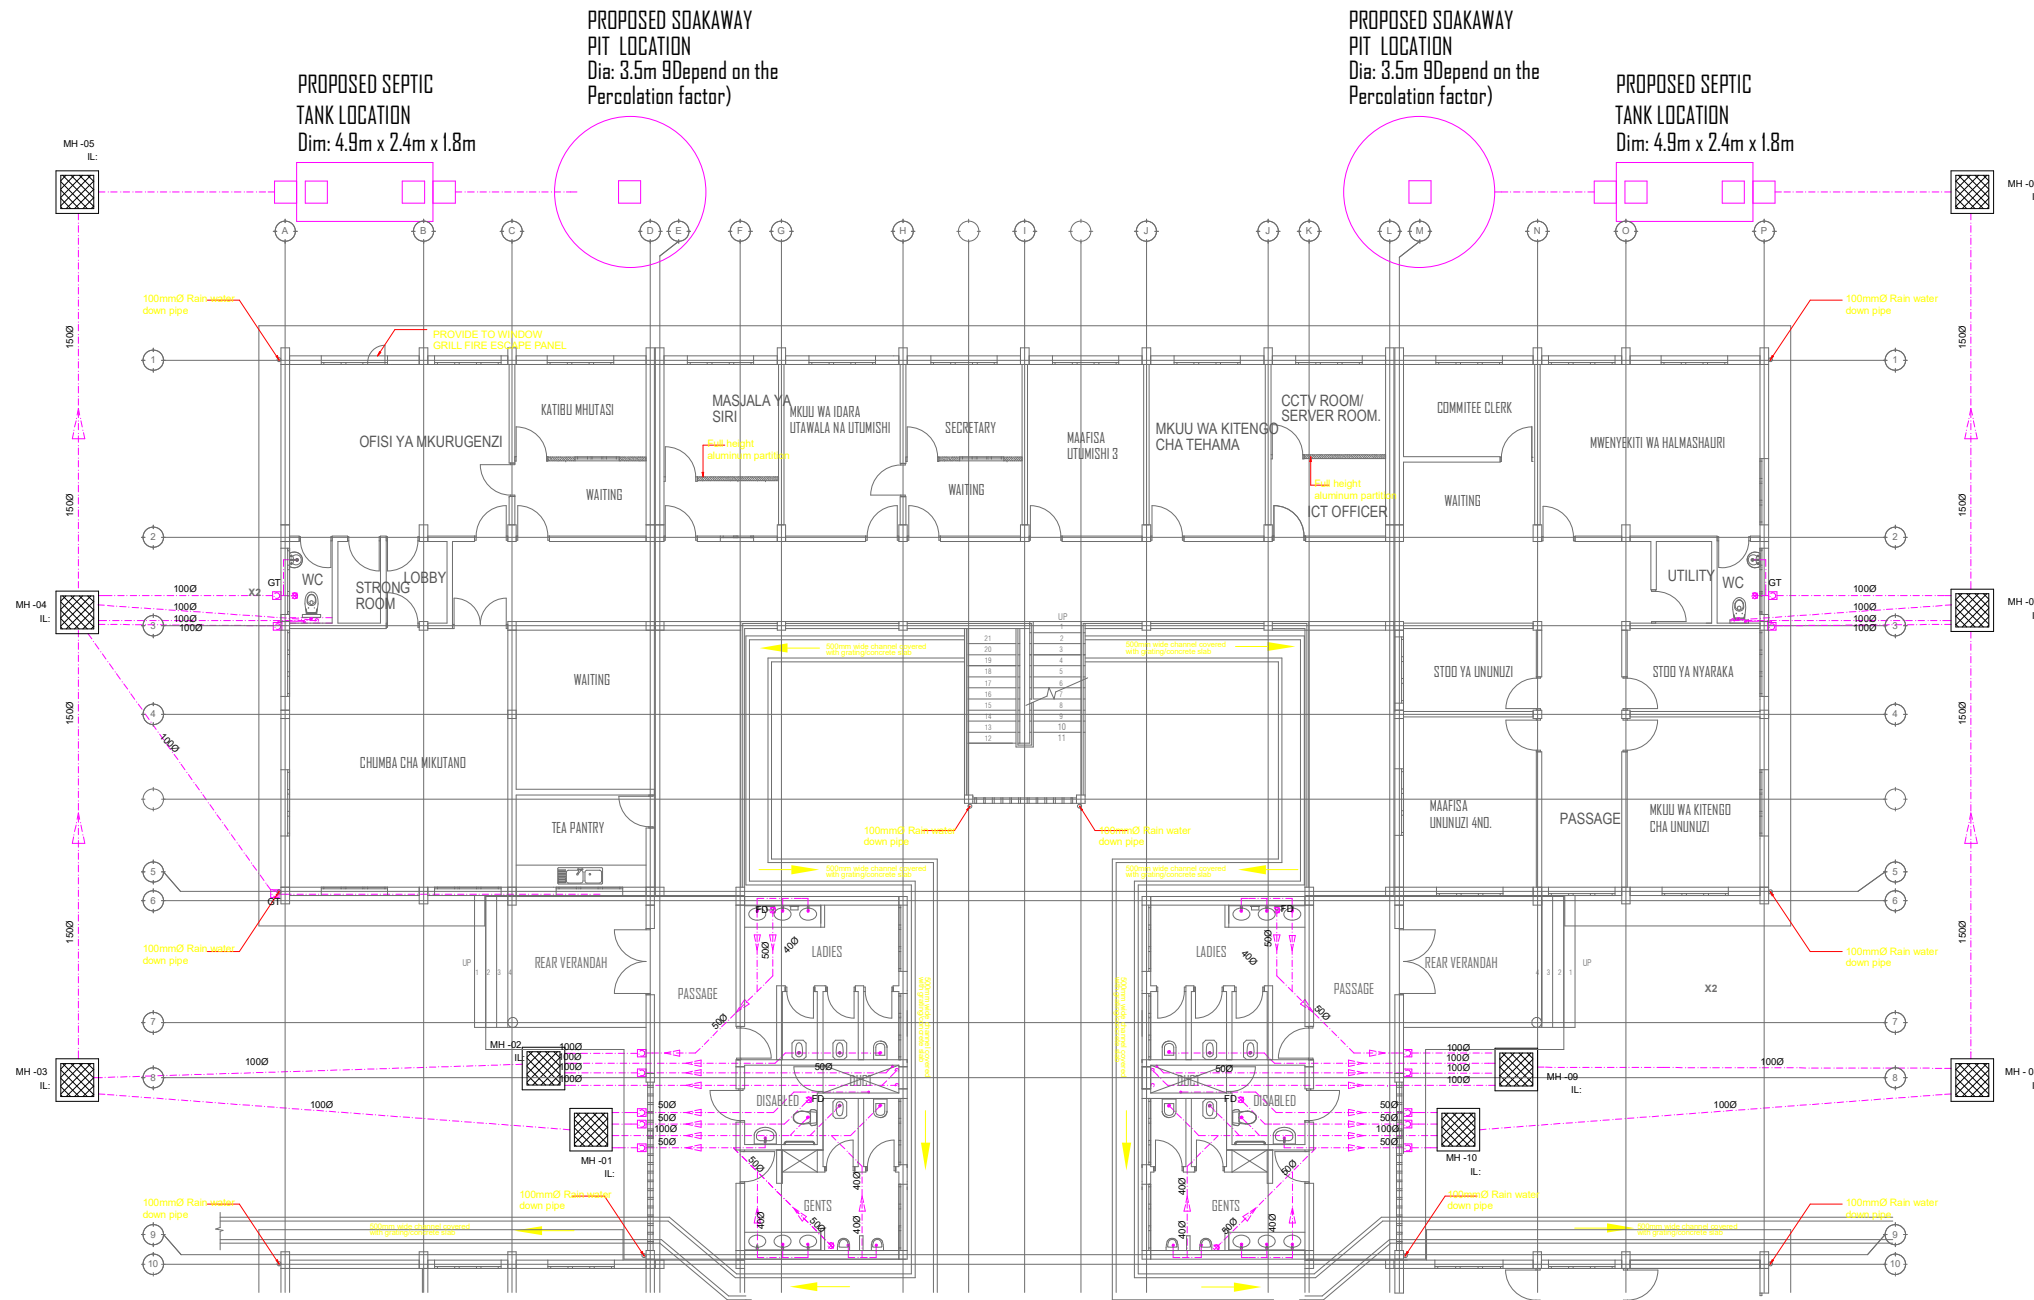

President's Office, Regional Administration  
and Local Government.  
Government City - Mtumba,  
TAMISEMI Street P.O. Box 1923,  
41185 Dodoma

**Client**  
PRESIDENT'S OFFICE,  
REGIONAL ADMINISTRATION AND LOCAL GOVERNMENT,  
GOVERNMENT CITY - MTUMBA  
TAMISEMI STREET,P.O. BOX 1923, 41185 DODOMA


**Project**  
PROPOSED STANDARD DRAWINGS FOR DISTRICT COUNCIL OFFICES

Drawing title  
**DRAINAGE SYSTEM**  
Ground Floor Plan

Project number	<b>D/105B</b>
Date MARCH 2020	
Drawn by HSN	
Checked by JR	
Scale 1:100	

## NOTES AND SYMBOL LEGED

1. All Dimensions are in mm
2. ——— Waste/Grey Water Pipe
3. ——— Cold Water Pipe
4. MH Manhole
5. FD Floor Drain
6. IL Invert Level
7. GT Gully Trap

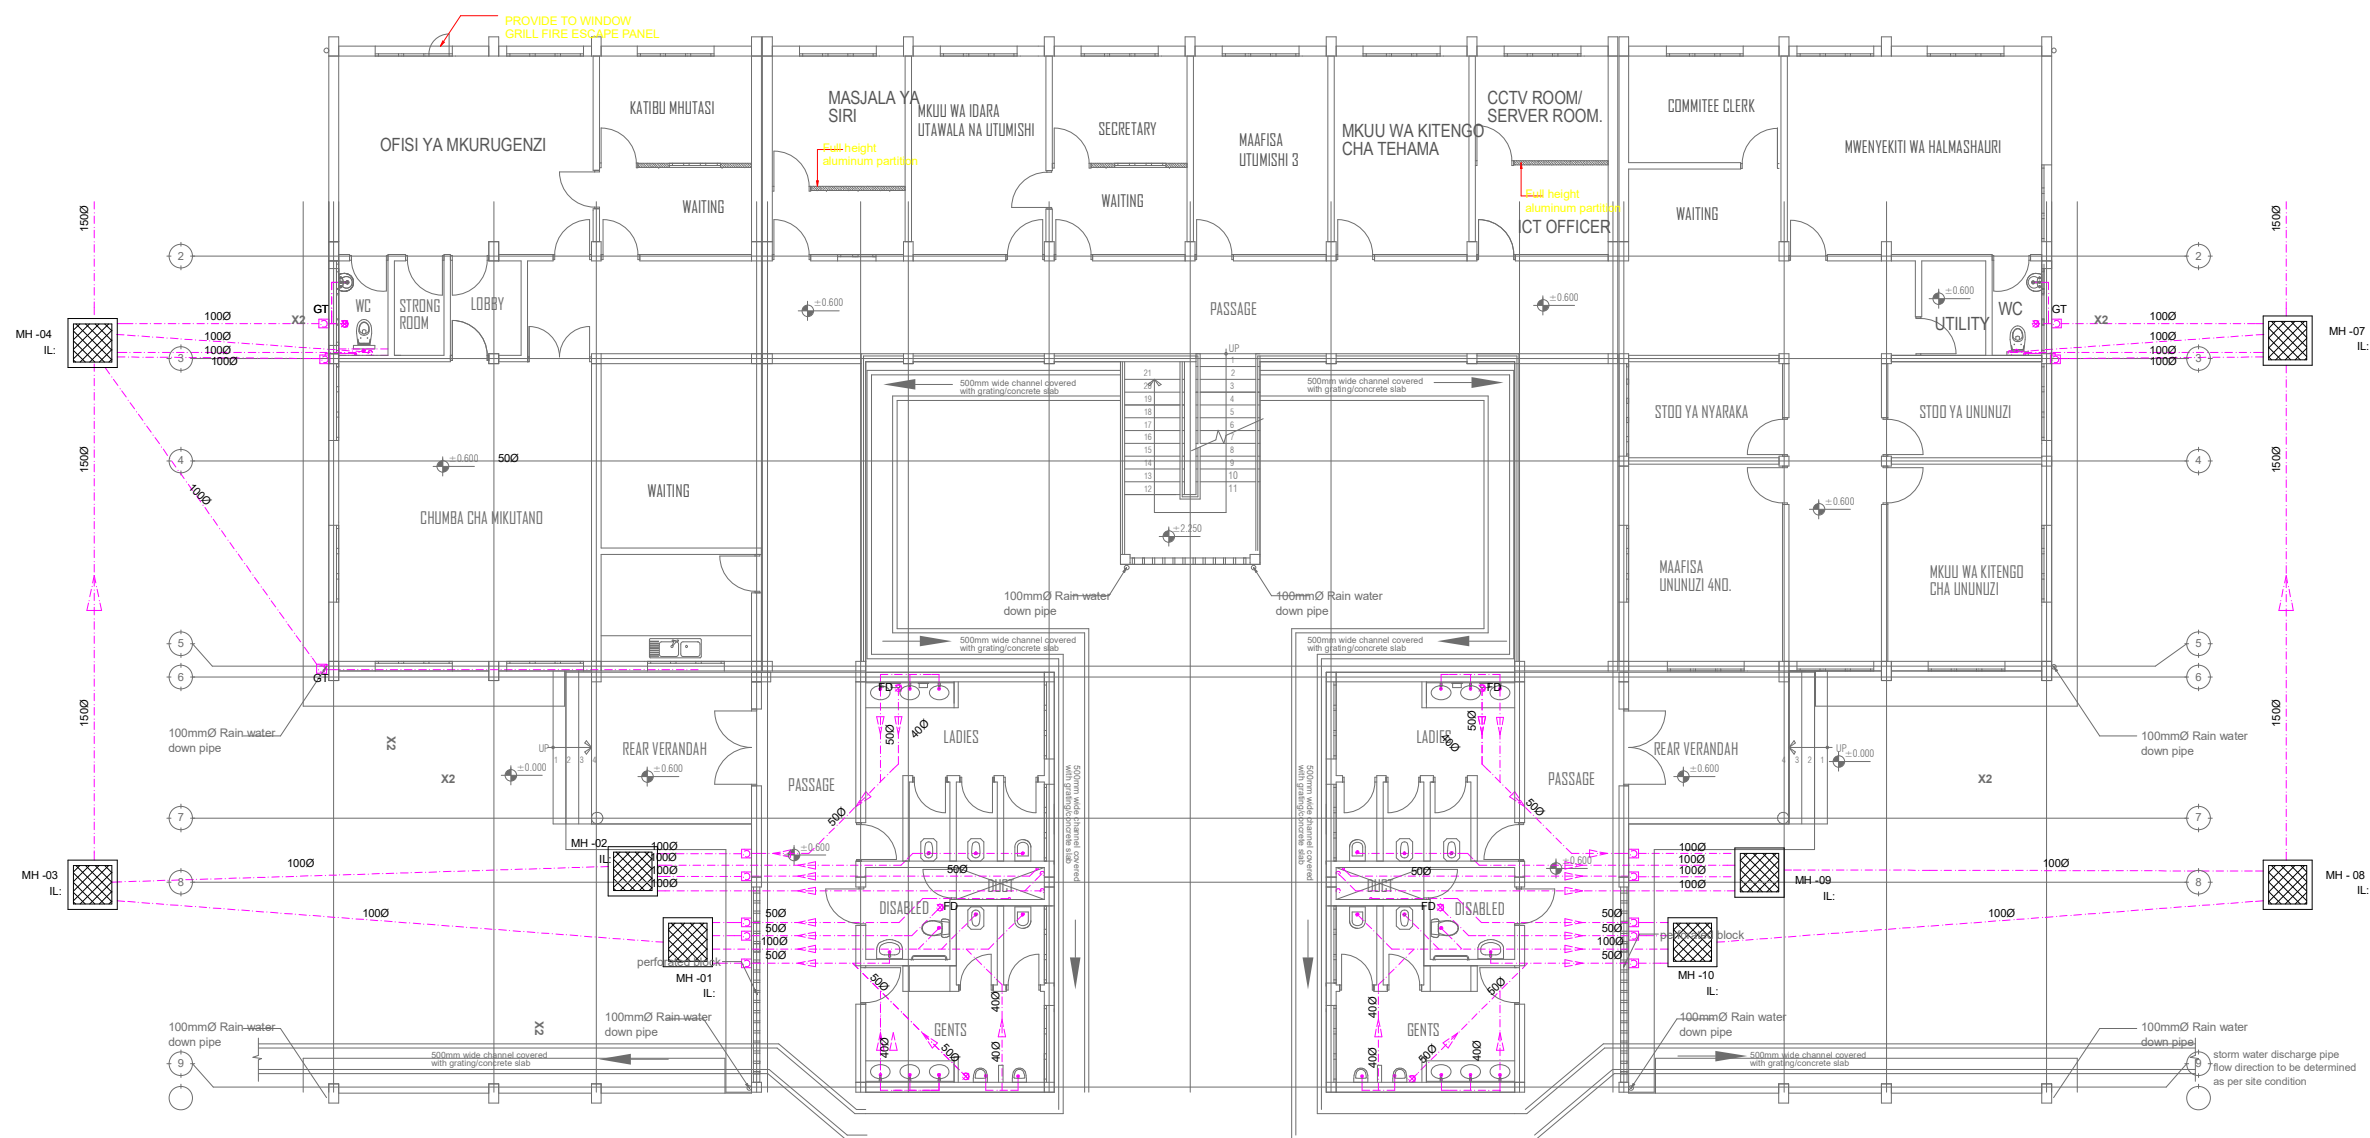

## DETAILED DRAINAGE SYSTEM

President's Office, Regional Administration  
and Local Government.  
Government City - Mtumba,  
TAMISEMI Street P.O. Box 1923,  
41185 Dodoma

**Client**  
PRESIDENT'S OFFICE,  
REGIONAL ADMINISTRATION AND LOCAL GOVERNMENT,  
GOVERNMENT CITY - MTUMBA  
TAMISEMI STREET, P.O. BOX 1923, 41185 DODOMA

**Project**  
PROPOSED STANDARD DRAWINGS FOR DISTRICT COUNCIL OFFICES

Drawing title

**DETAILED DRAINAGE SYSTEM**  
Ground Floor Plan

Project number

Date MARCH 2020

Drawn by HSN


Checked by JR

**D/105C**

Scale 1:100

## NOTES AND SYMBOL LEGED

1. All Dimensions are in mm
2. ——— Waste/Grey Water Pipe
3. ——— Cold Water Pipe
4. MH Manhole
5. FD Floor Drain
6. IL Invert Level
7. GT Gully Trap

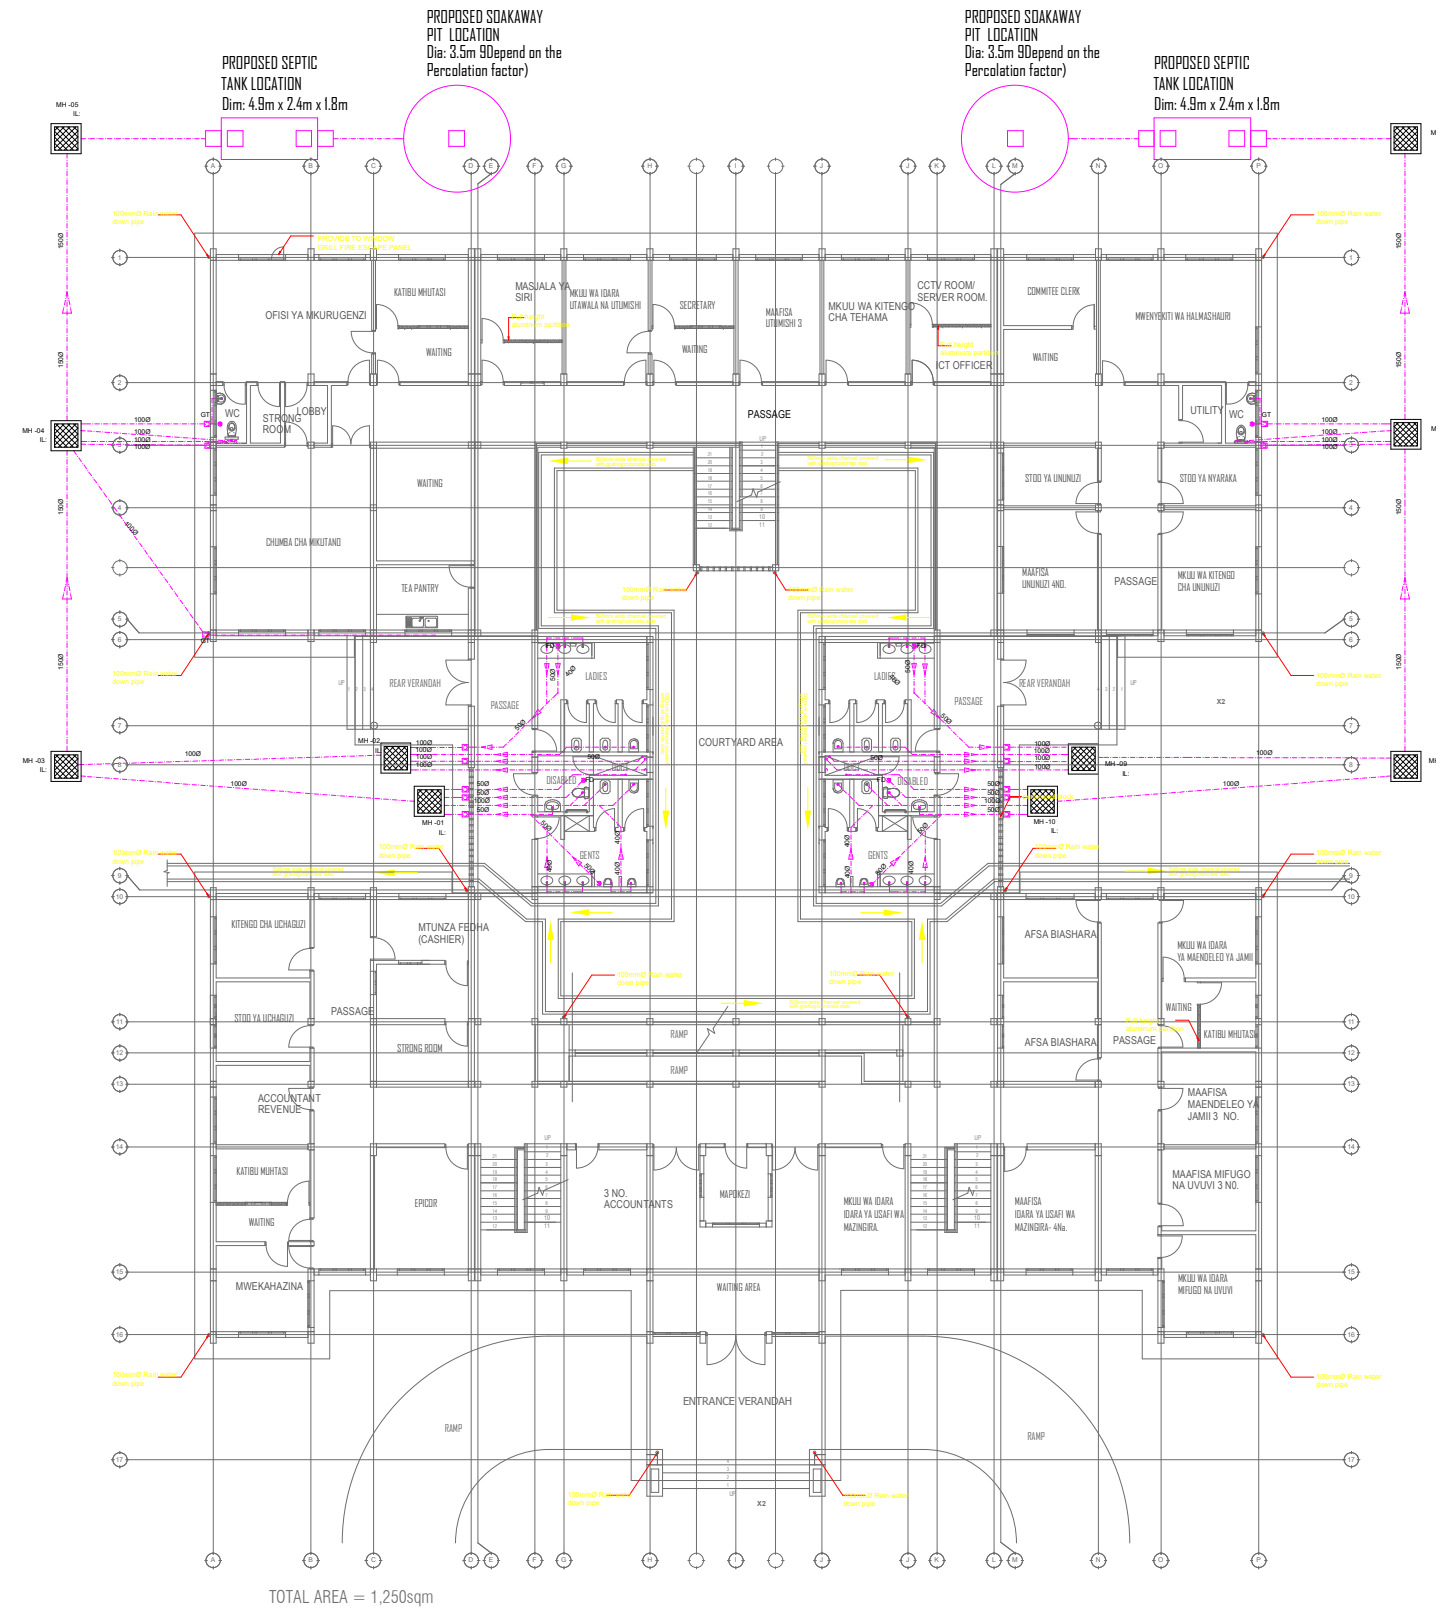

### GROUND FLOOR PLAN

President's Office, Regional Administration  
and Local Government.  
Government City - Mtumba,  
TAMISEMI Street P.O. Box 1923,  
41185 Dodoma

#### Client

PRESIDENT'S OFFICE,  
REGIONAL ADMINISTRATION AND LOCAL GOVERNMENT,  
GOVERNMENT CITY - MTUMBA  
TAMISEMI STREET,P.O. BOX 1923, 41185 DODOMA

#### Project

PROPOSED STANDARD DRAWINGS FOR DISTRICT COUNCIL OFFICES

#### Drawing title

**DRAINAGE SYSTEM**  
Ground Floor Plan

Project number

Date MARCH 2020

Drawn by HSN

Checked by JR

**D/105A**

Scale 1:100