

**KEY:**


--- PVC PIPE 100mm Ø

☐ GT GULLY TRAP

☐ MANHOLE

● VP VENT PIPE

⊕ FD FLOOR DRAIN

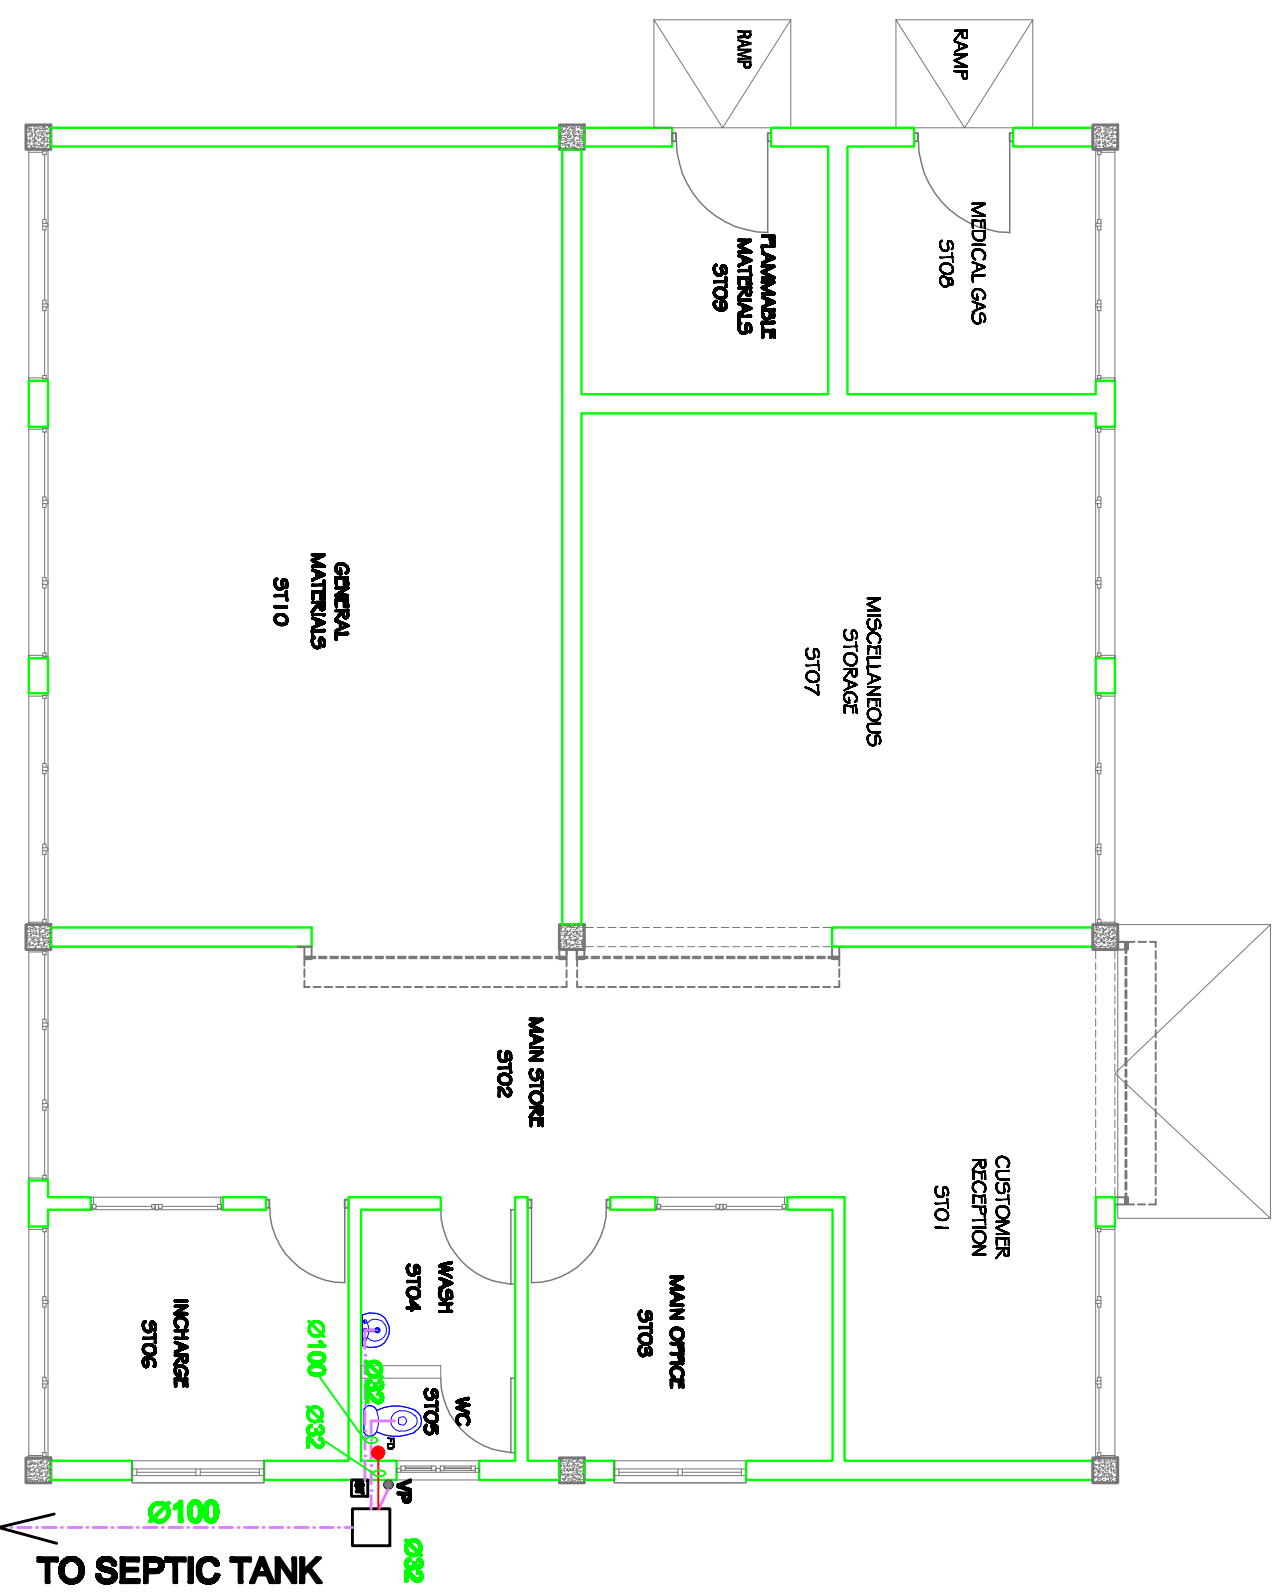

# GROUND PLAN

SCALE: 1:200

Building Section  
 Planning and Policy Department  
 Ministry of Health, Community Development,  
 Gender Elderly and Children,  
 University of Dodoma  
 College of Humanities and Social Sciences | 11th  
 Building, P.O. Box 743,  
 40470 Dodoma

In Collaboration with  
 President's Office, Regional Administration  
 and Local Governments,  
 Sokome Building,  
 P.O. Box 1923,  
 41185 Dodoma

Client  
**PRESIDENTS OFFICE, REGIONAL ADMINISTRATION AND LOCAL GOVERNMENTS,  
 MKAPA BUILDING, P.O. BOX 1923, 41185 DODOMA**

Project  
**STANDARD DESIGN FOR COUNCIL LEVEL HOSPITALS IN TANZANIA**

**Drawing title**

**MAIN STORE  
 DRAINAGE LAYOUT**

Project number	MS DR/101
Drawn by	ACJ
Checked by	JCR
Date	24 APRIL 2018
Scale	1:100