


WATER FROM SUPPLY

**KEY**

- IPS PIPE
- POLY PIPE
- CONTROL VALVE

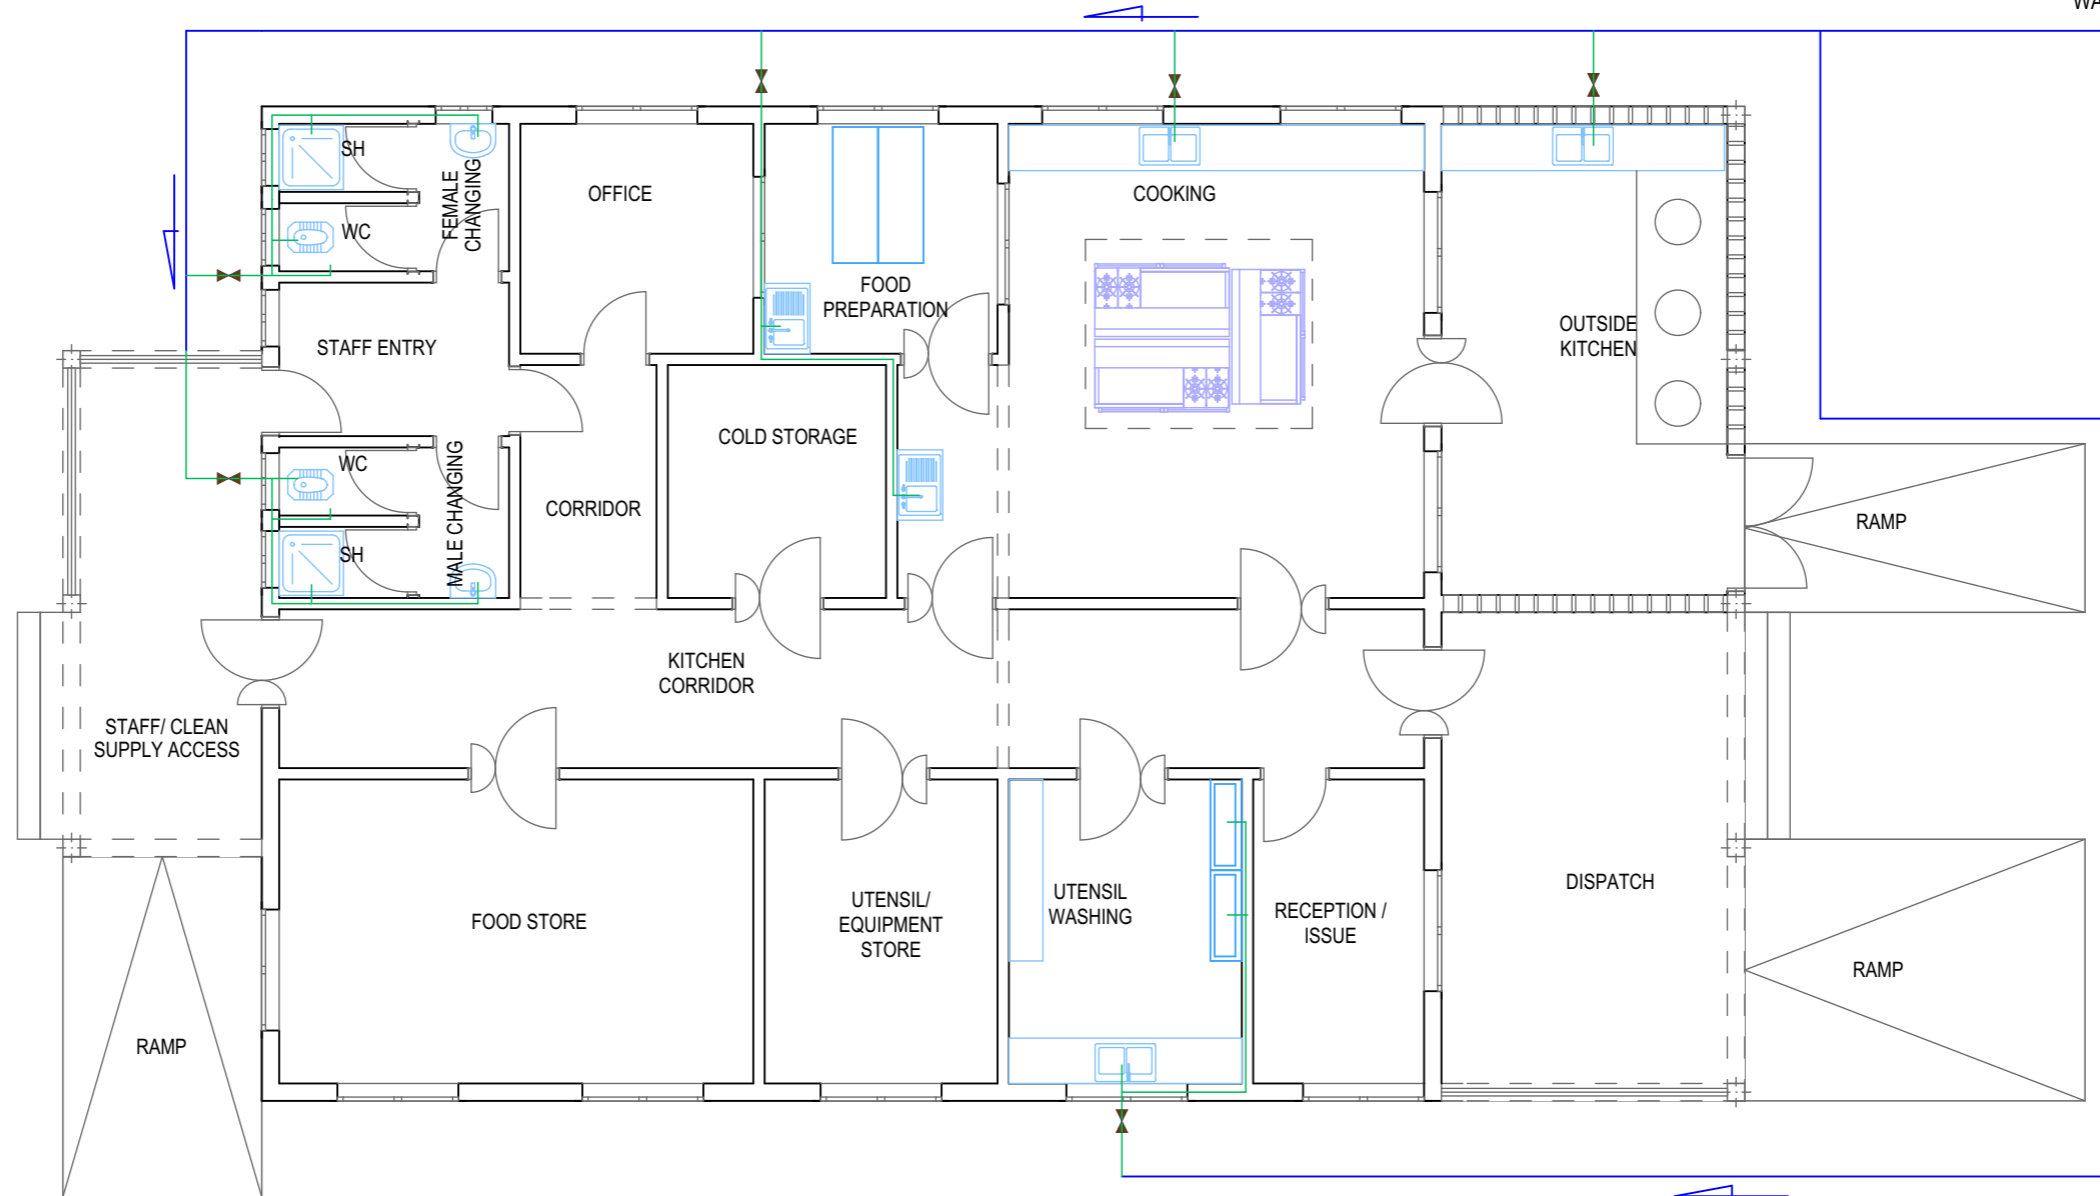

**FLOOR PLAN**

Building Section  
 Planning and Policy Department  
 Ministry of Health, Community Development,  
 Gender Elderly and Children.  
 University of Dodoma  
 College of Humanities and Social Science 11th  
 Building, P.O. Box 743,  
 40478 Dodoma

In Collaboration with President's Office, Regional Administration  
 and Local Government.  
 Mkapa Building,  
 P.O. Box 1923,  
 41185 Dodoma

Client  
 PRESIDENT'S OFFICE, REGIONAL ADMINISTRATION AND  
 LOCAL GOVERNMENT, MKAPA BUILDING,  
 P.O. BOX 1923, 41185 DODOMA

Project  
 STANDARD DESIGN FOR COUNCIL LEVEL HOSPITALS IN  
 TANZANIA

Drawing title		KITCHEN BLOCK WATER LAYOUT	
Project number		KIT/W101	
Date	May, 2018		
Drawn by	AAI		
Checked by	ACJ		
	Scale	1:150	