

 


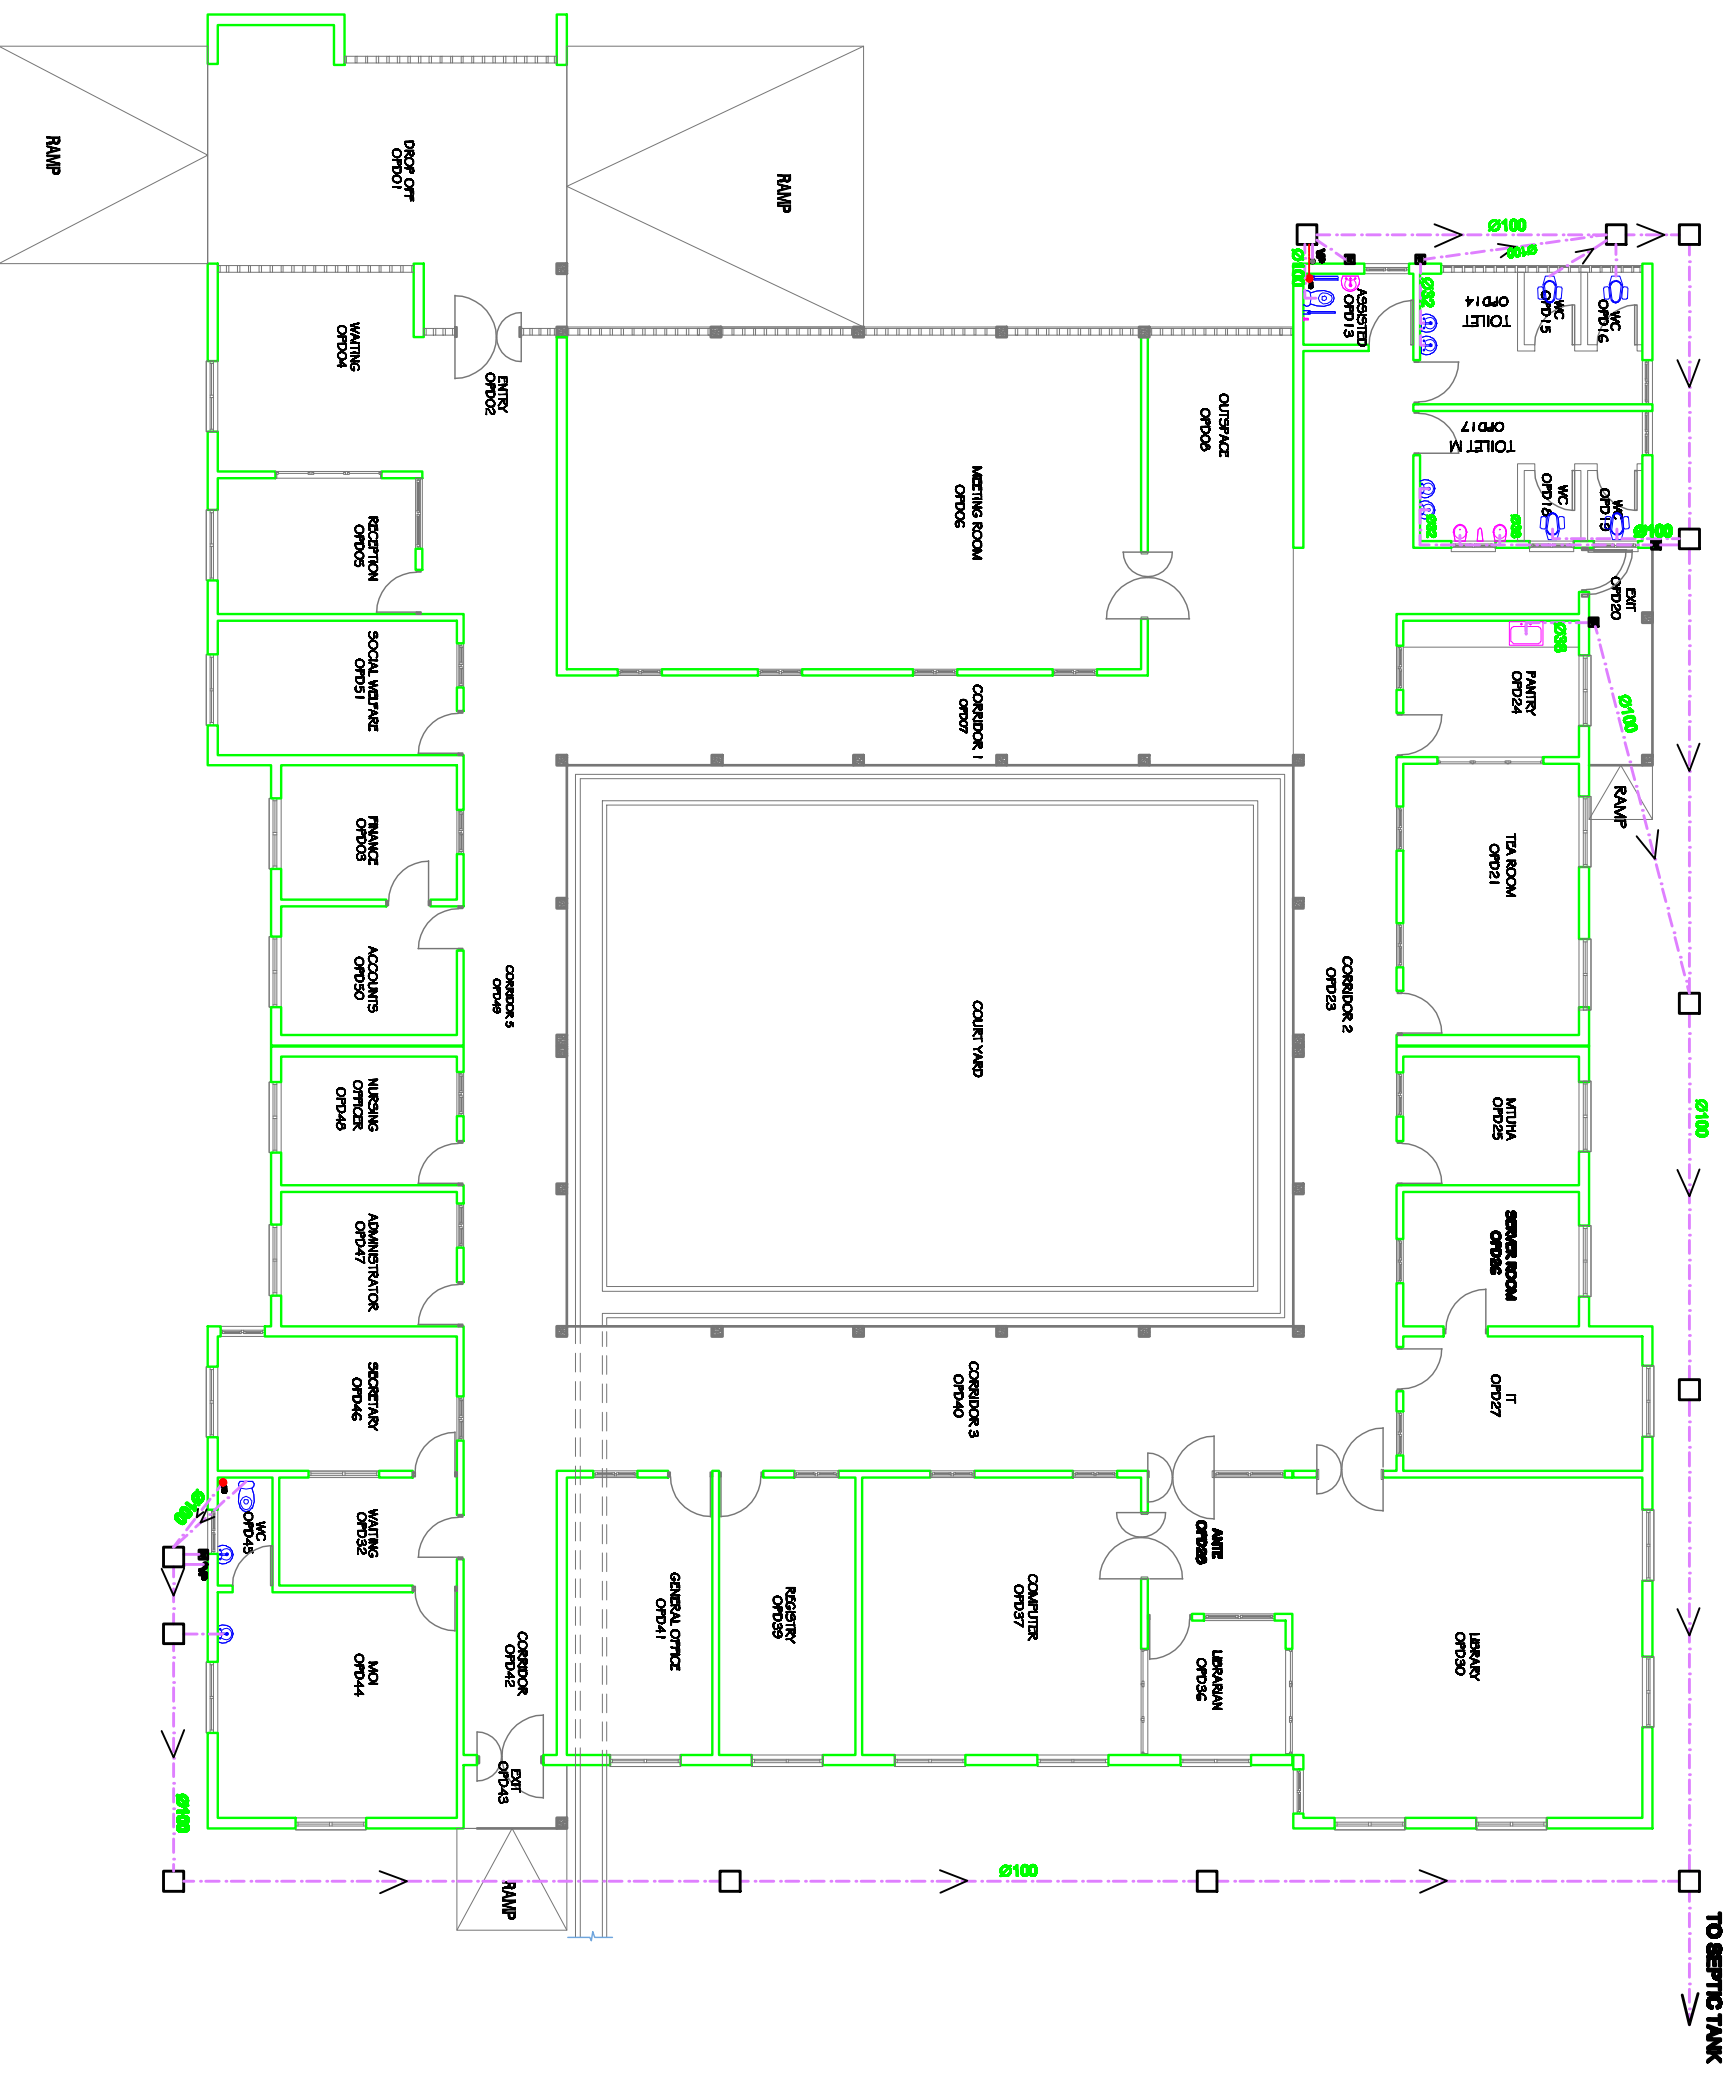


- KEY:**
-  PVC PIPE 100mm Ø
 -  GULLY TRAP
 -  MANHOLE
 -  VENT PIPE
 -  FLOOR DRAIN



GROUND PLAN

SCALE: 1:200

Building Section
 Planning and Policy Department
 Ministry of Health, Community Development,
 Gender Elderly and Children,
 University of Dodoma
 College of Humanities and Social Sciences 11th
 Building, P.O. Box 743,
 40470 Dodoma

In Collaboration with
 President's Office, Regional Administration
 and Local Governments,
 Sokome Building,
 P.O. Box 1923,
 41185 Dodoma

Client
**PRESIDENTS OFFICE, REGIONAL ADMINISTRATION AND LOCAL GOVERNMENTS,
 MKAPA BUILDING, P.O. BOX 1923, 41185 DODOMA**

Project
STANDARD DESIGN FOR COUNCIL LEVEL HOSPITALS IN TANZANIA

Drawing title	
ADMINISTRATION BLOCK DRAINAGE LAYOUT	
Project number	ADMIN DR7101
Drawn by	ACJ
Checked by	JCR
24 APRIL 2018	Scale 1:200