

KEY:

--- PVC PIPE 100mm Ø

□ GT
GULLY TRAP


□ MANHOLE

● VP
VENT PIPE

⊕ FD
FLOOR DRAIN

GROUND PLAN

SCALE: 1:200

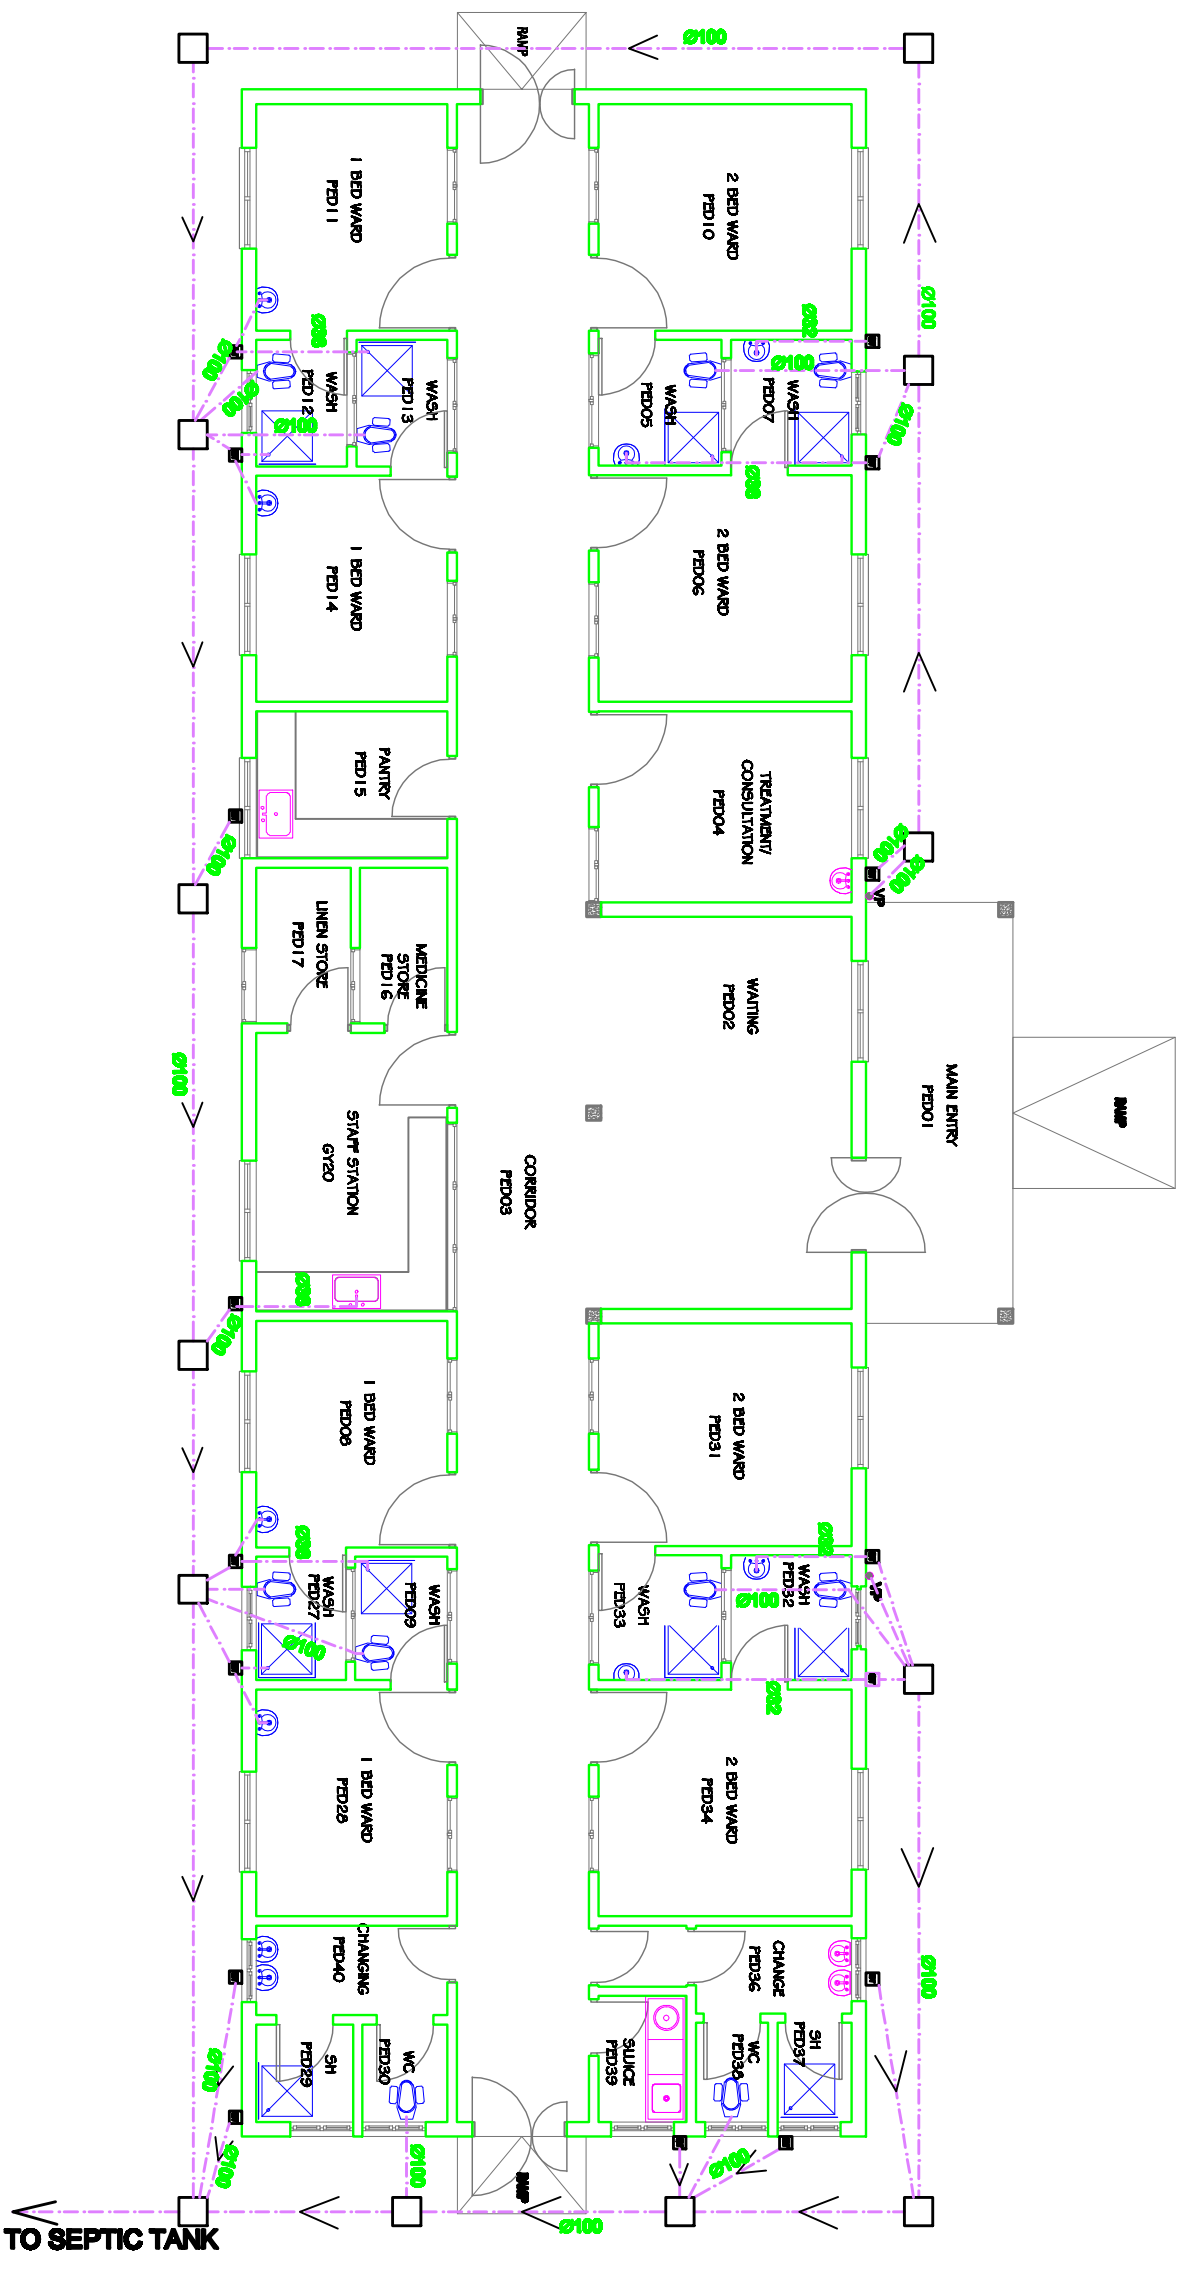

Building Section
Planning and Policy Department
Ministry of Health, Community Development,
Gender Elderly and Children,
University of Dodoma
College of Humanities and Social Sciences 11th
Building, P.O. Box 743,
40470 Dodoma

In Collaboration with
President's Office, Regional Administration
and Local Governments,
Sokome Building,
P.O. Box 1923,
41185 Dodoma

Client
**PRESIDENTS OFFICE, REGIONAL ADMINISTRATION AND LOCAL GOVERNMENTS,
MKAPA BUILDING, P.O. BOX 1923, 41185 DODOMA**

Project
STANDARD DESIGN FOR COUNCIL LEVEL HOSPITALS IN TANZANIA

Drawing title

**GRADE ONE WARD
DRAINAGE LAYOUT**

Project number

24 APRIL 2018

Drawn by

ACJ

GI DR/101

Checked by

JCR

Scale 1:100