

KEY:


--- PVC PIPE 100mm Ø

□ GT GULLY TRAP

□ MANHOLE

● VP VENT PIPE

⊕ FD FLOOR DRAIN

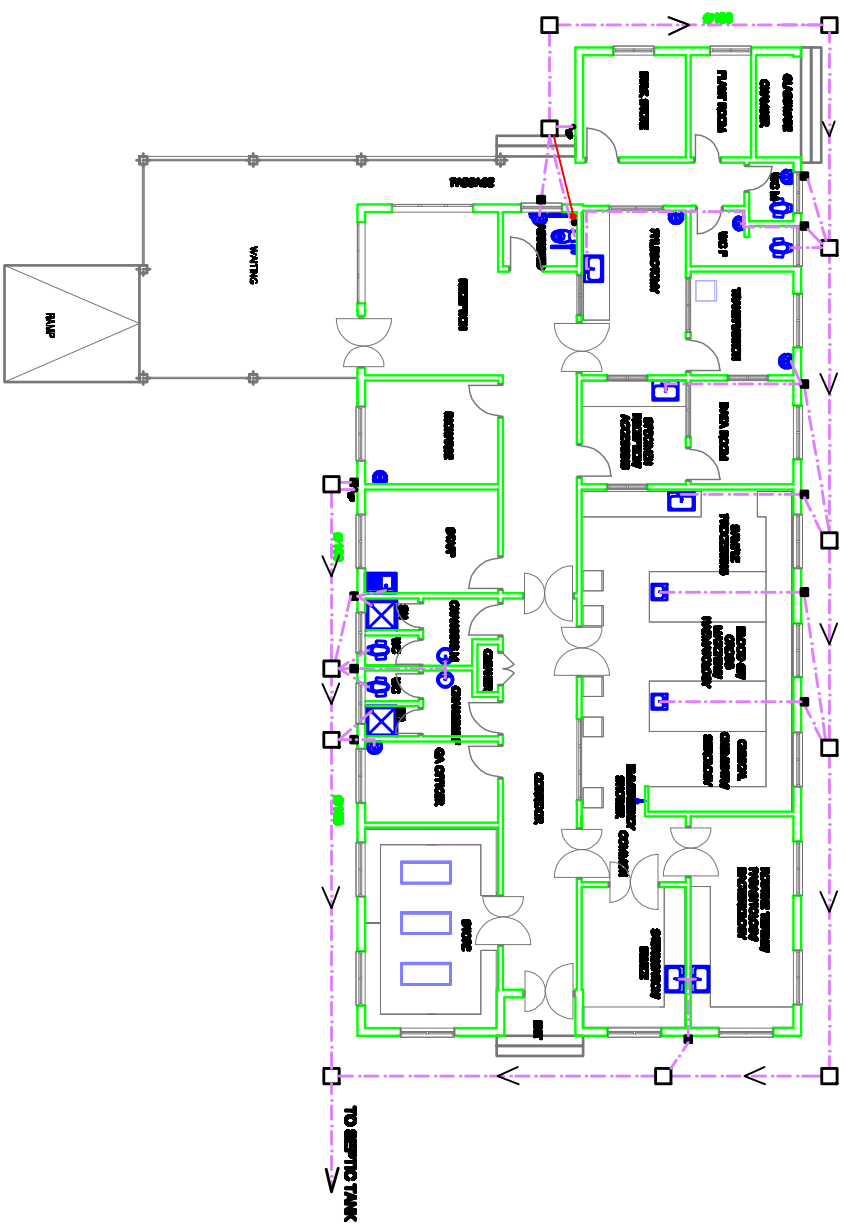

GROUND PLAN

SCALE: 1:100

LABORATORY

Building Section
 Planning and Policy Department
 Ministry of Health, Community Development,
 Gender Elderly and Children,
 University of Dodoma
 College of Humanities and Social Sciences 11th
 Building, P.O. Box 743,
 40470 Dodoma

In Collaboration with
 President's Office, Regional Administration
 and Local Government,
 Mkapa Building,
 P.O. Box 1923,
 41185 Dodoma

Client
**PRESIDENTS OFFICE, REGIONAL ADMINISTRATION AND LOCAL GOVERNMENTS,
 MKAPA BUILDING, P.O. BOX 1923, 41185 DODOMA**

Project
STANDARD DESIGN FOR COUNCIL LEVEL HOSPITALS IN TANZANIA

Drawing title

**LABORATORY BLOCK
 DRAINAGE LAYOUT**

Project number	L DR/101
Drawn by	ACJ
Checked by	JCR
Date	24 APRIL 2018
Scale	1:100