

KEY:


--- PVC PIPE 100mm Ø

□ GT
GULLY TRAP

□ MANHOLE

● VP
VENT PIPE

⊗ FD
FLOOR DRAIN

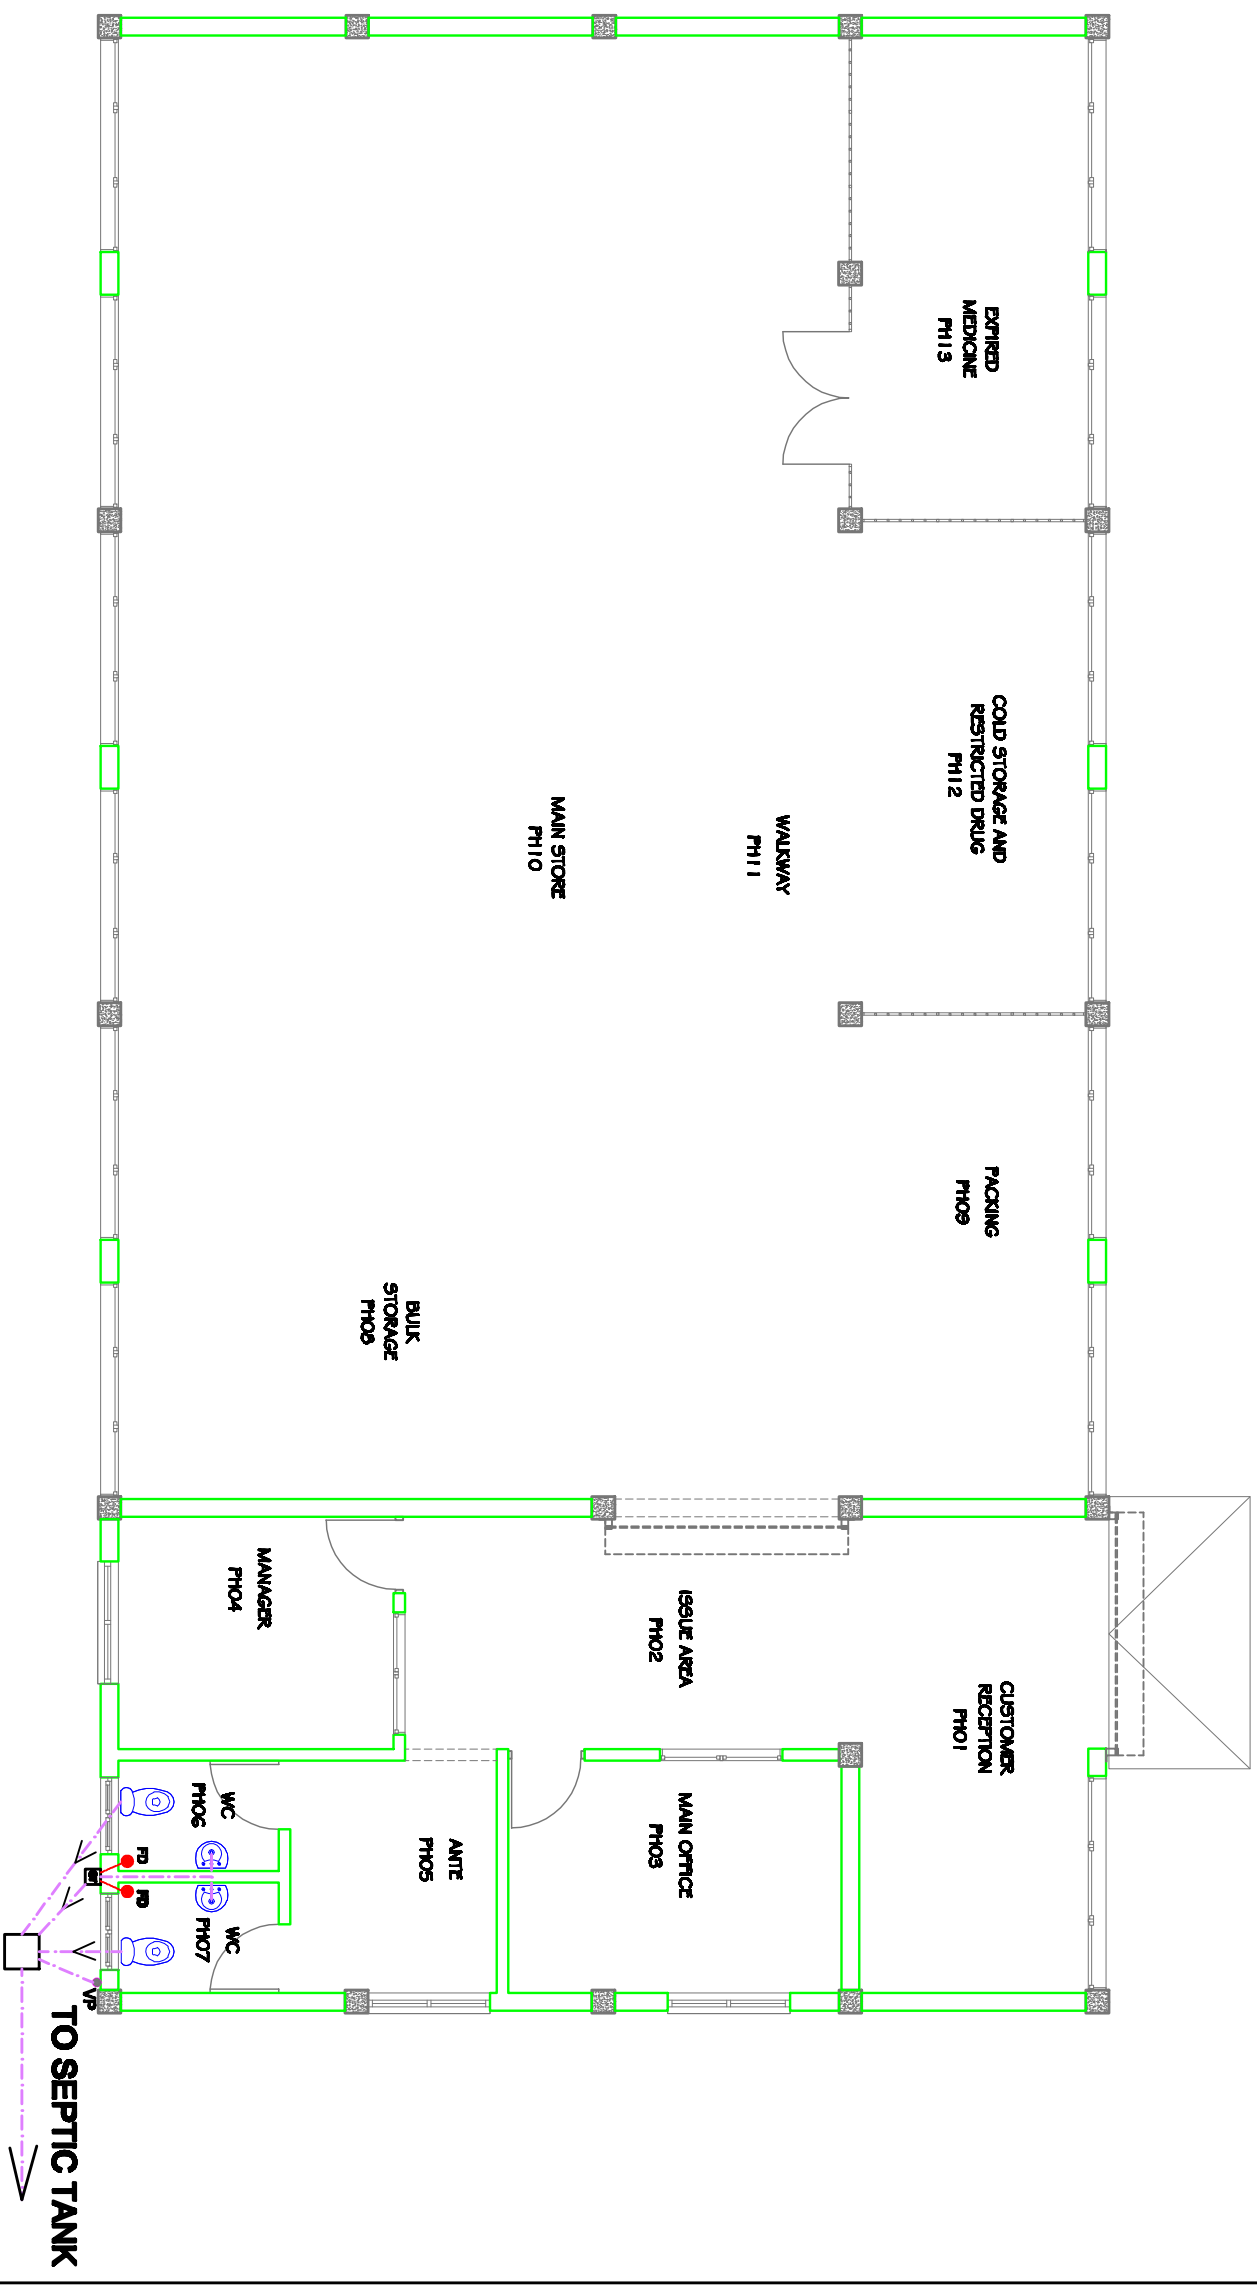

GROUND PLAN

SCALE: 1:200

Building Section
Planning and Policy Department
Ministry of Health, Community Development,
Gender Elderly and Children,
University of Dodoma
College of Humanities and Social Science 11th
Building, P.O. Box 748,
40476 Dodoma

In Collaboration with
President's Office, Regional Administration
and Local Governments.
Sokoma Building,
P.O. Box 1923,
41185 Dodoma

Client
**PRESIDENT'S OFFICE, REGIONAL ADMINISTRATION AND LOCAL GOVERNMENTS,
MKAPA BUILDING, P.O. BOX 1923, 41185 DODOMA**

Project
STANDARD DESIGN FOR COUNCIL LEVEL HOSPITALS IN TANZANIA

Drawing title
**PHARMACY BLOCK
DRAINAGE LAYOUT**

Project number	PH DR/101
Drawn by	24 APRIL 2018 ACJ
Checked by	JCR
Scale	1:100