

KEY:


--- PVC PIPE 100mm Ø

GT GULLY TRAP

MANHOLE

VP VENT PIPE

FD FLOOR DRAIN

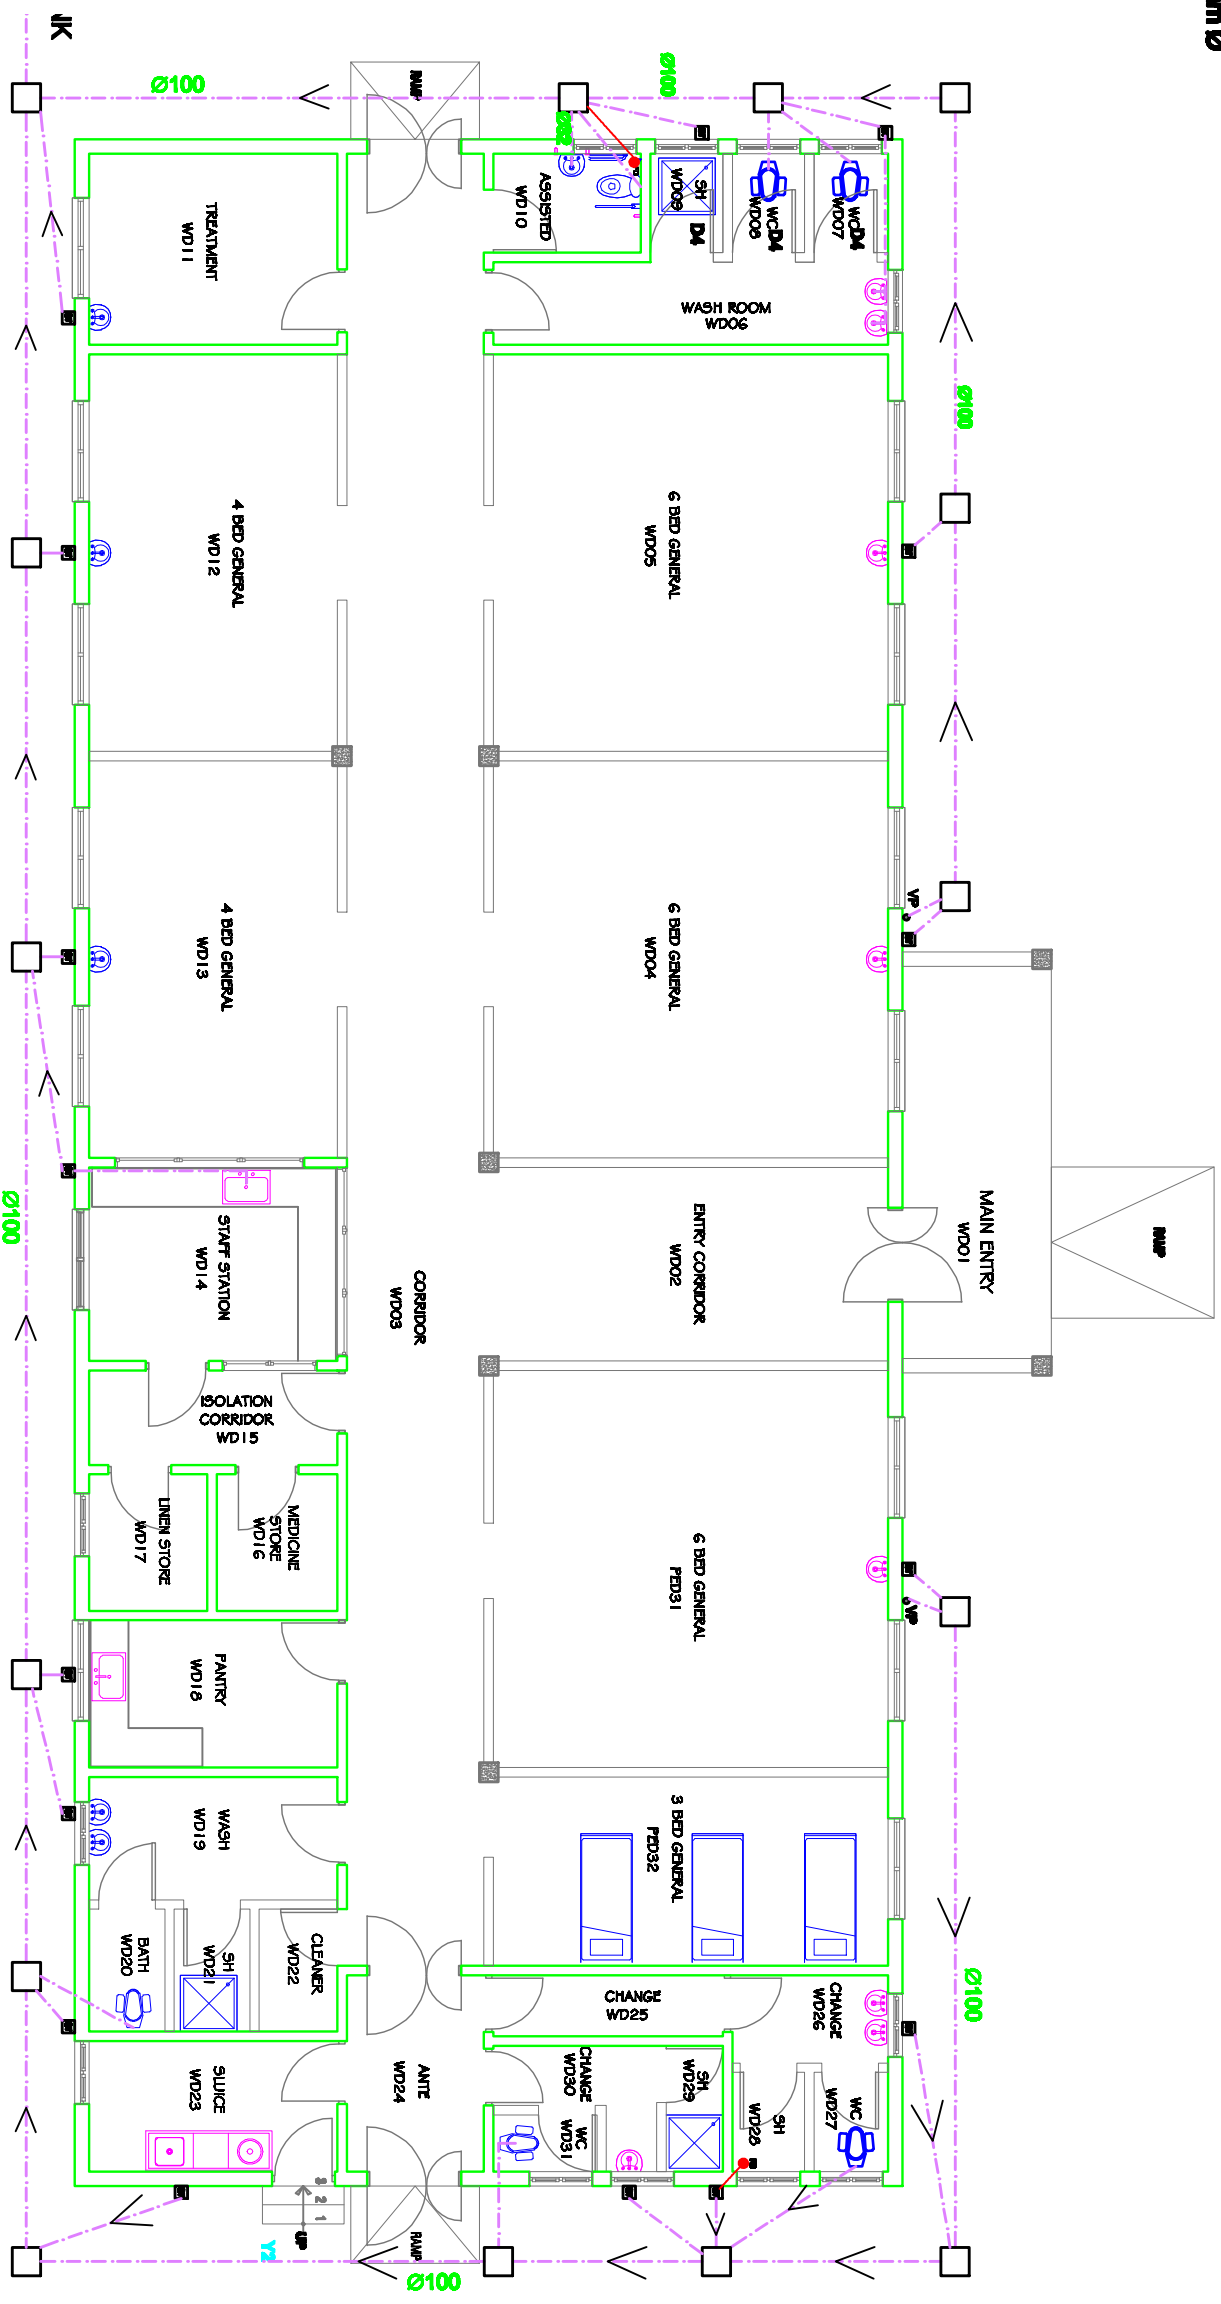

GROUND PLAN

SCALE: 1:200

Building Section
 Planning and Policy Department
 Ministry of Health, Community Development,
 Gender Elderly and Children,
 University of Dodoma
 College of Humanities and Social Sciences 11th
 Building, P.O. Box 743,
 40470 Dodoma

In Collaboration with
 President's Office, Regional Administration
 and Local Governments,
 Sokoma Building,
 P.O. Box 1923,
 41185 Dodoma

Client
PRESIDENTS OFFICE, REGIONAL ADMINISTRATION AND LOCAL GOVERNMENTS,
MKAPA BUILDING, P.O. BOX 1923, 41185 DODOMA

Project
STANDARD DESIGN FOR COUNCIL LEVEL HOSPITALS IN TANZANIA

Drawing title

**SURGICAL & MEDICAL WARDS
 DRAINAGE LAYOUT**

Project number	24 APRIL 2018	SIRW DR/101
Drawn by	ACJ	
Checked by	JCR	
Scale		1:100