




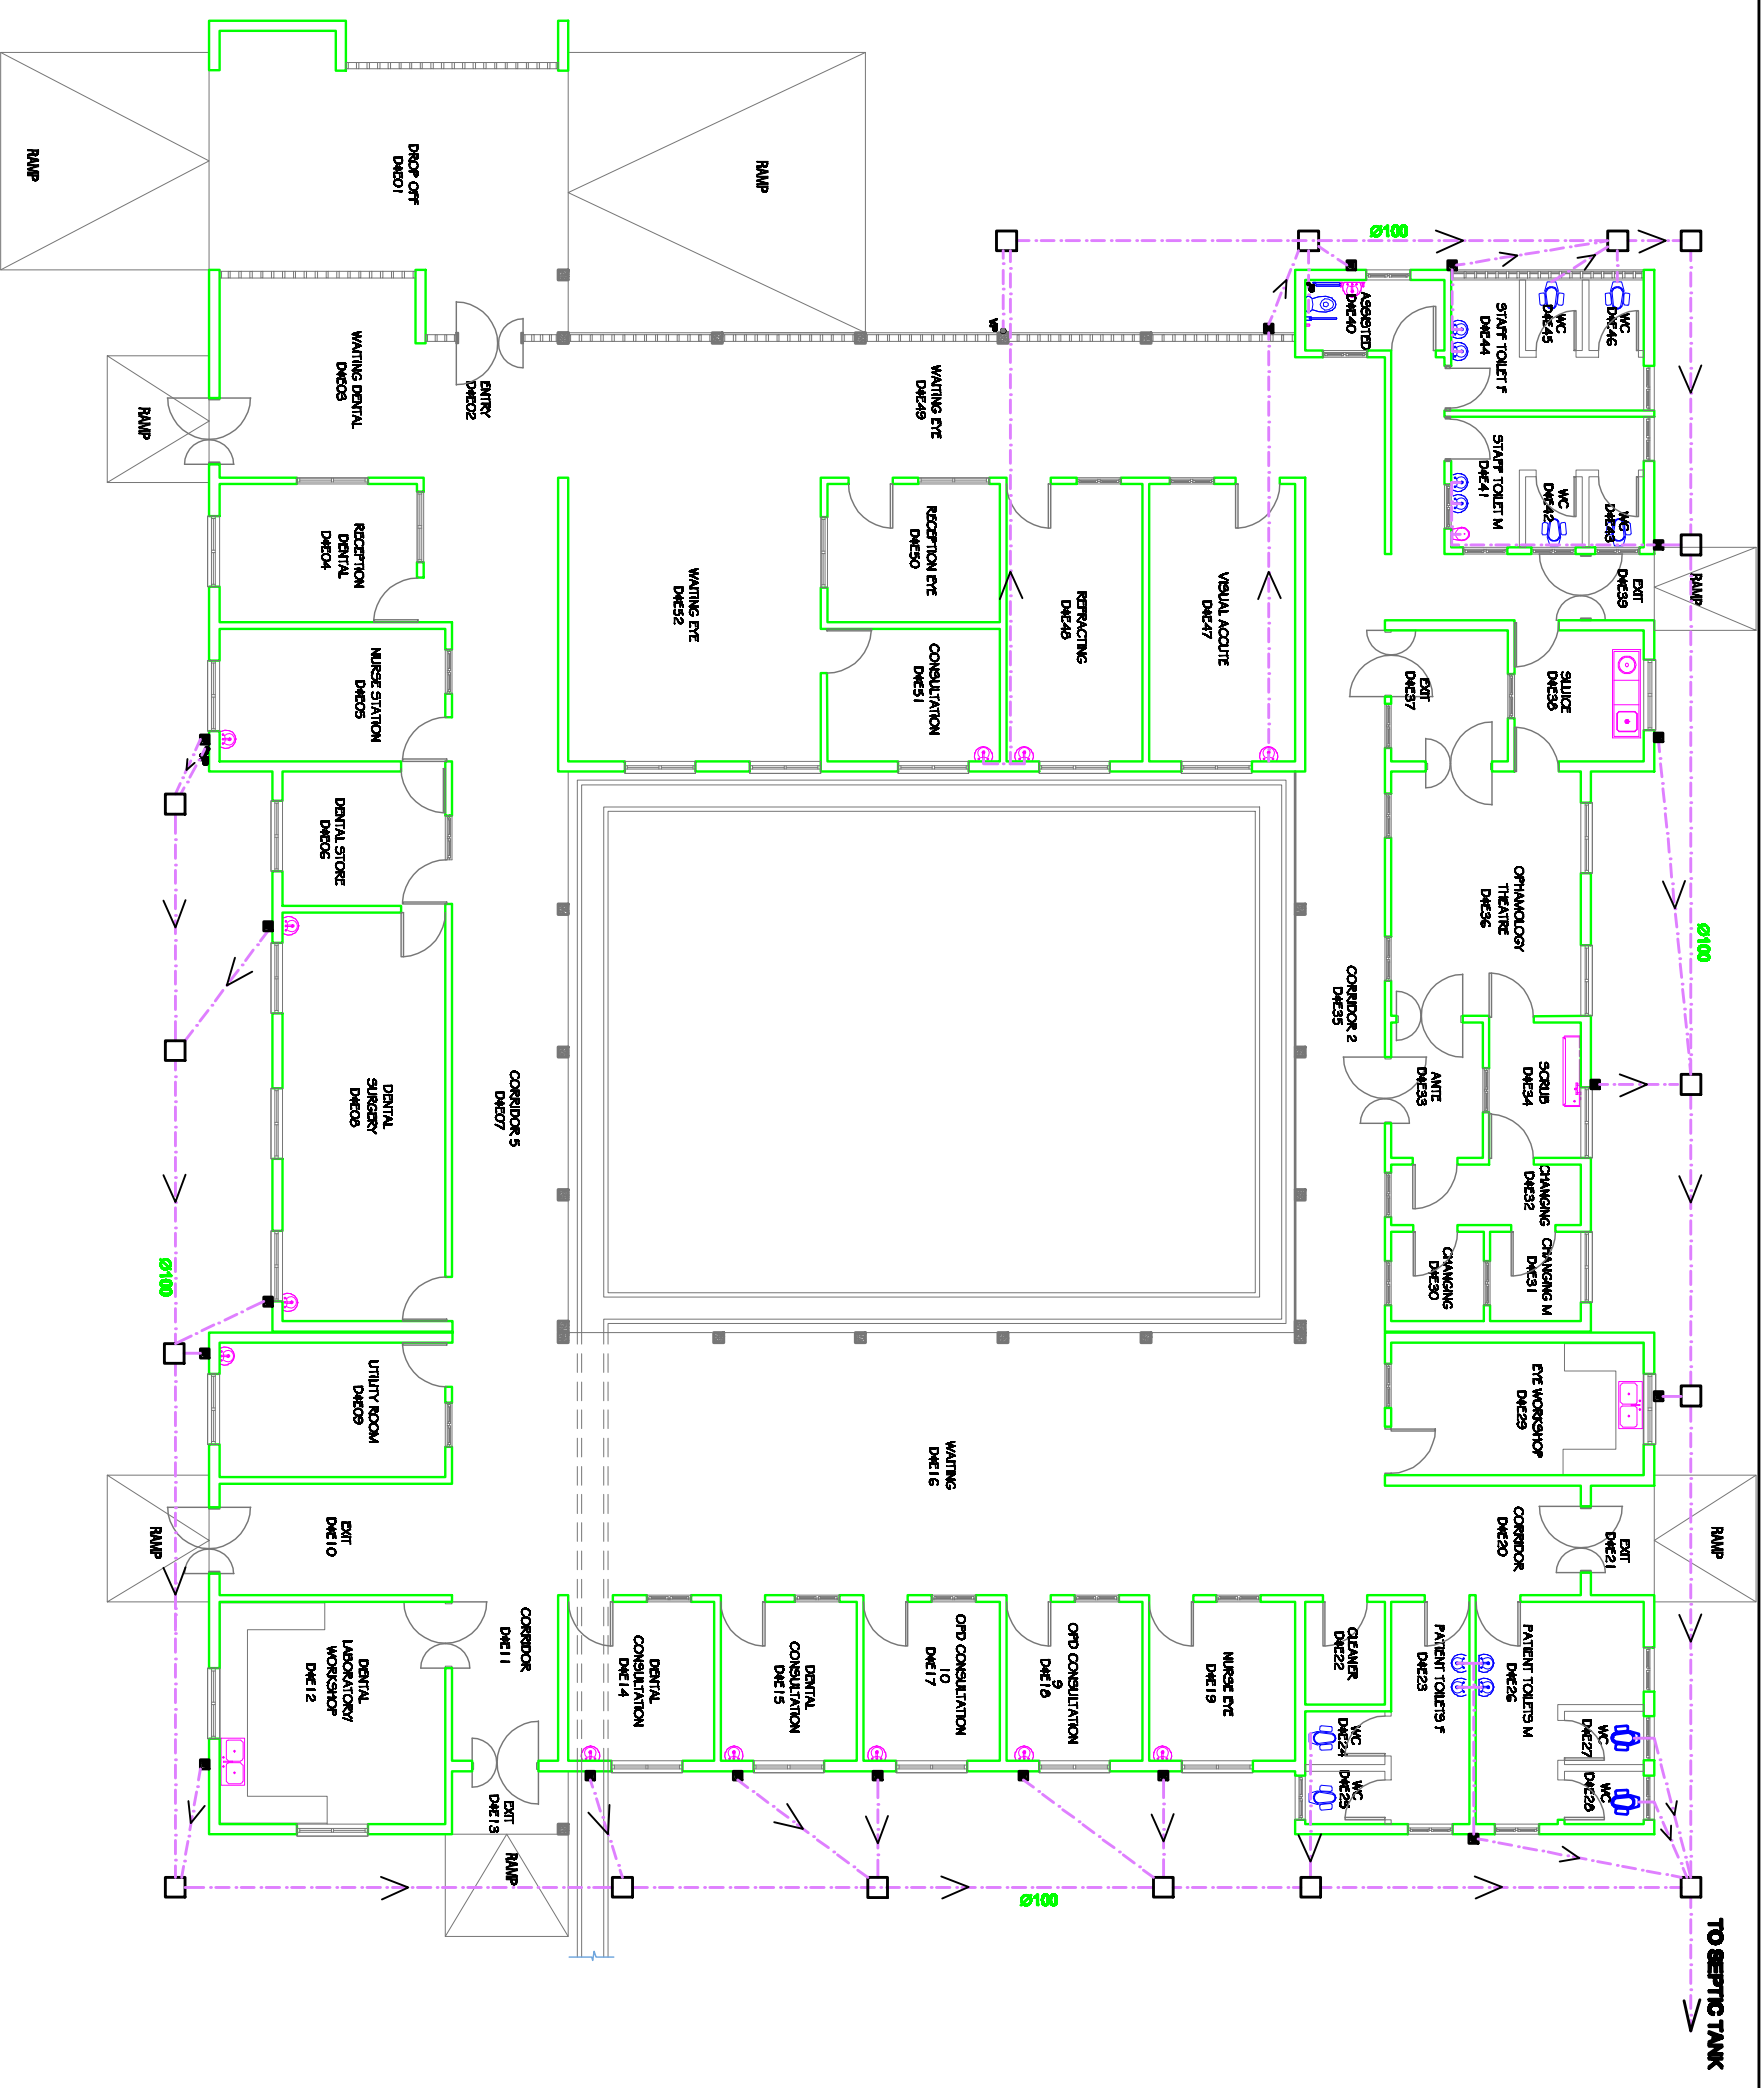


- KEY:**
-  PVC PIPE 100mm Ø
  -  GULLY TRAP
  -  MANHOLE
  -  VENT PIPE
  -  FLOOR DRAIN



# GROUND PLAN

SCALE: 1:200

Building Section  
 Planning and Policy Department  
 Ministry of Health, Community Development,  
 Gender Elderly and Children,  
 University of Dodoma  
 College of Humanities and Social Sciences 11th  
 Building, P.O. Box 743,  
 40470 Dodoma

In Collaboration with  
 President's Office, Regional Administration  
 and Local Governments,  
 Sokome Building,  
 P.O. Box 1923,  
 41185 Dodoma

Client  
**PRESIDENTS OFFICE, REGIONAL ADMINISTRATION AND LOCAL GOVERNMENTS,**  
**MKAPA BUILDING, P.O. BOX 1923, 41185 DODOMA**

Project  
**STANDARD DESIGN FOR COUNCIL LEVEL HOSPITALS IN TANZANIA**

Drawing title	
<b>DENTAL &amp; EYE BLOCK</b>	
<b>DRAINAGE LAYOUT</b>	
Project number	<b>DAE DR/101</b>
Drawn by	ACJ
Checked by	JCR
24 APRIL 2018	Scale 1:100