


KEY

- IPS PIPE
- POLY PIPE
- CONTROL VALVE

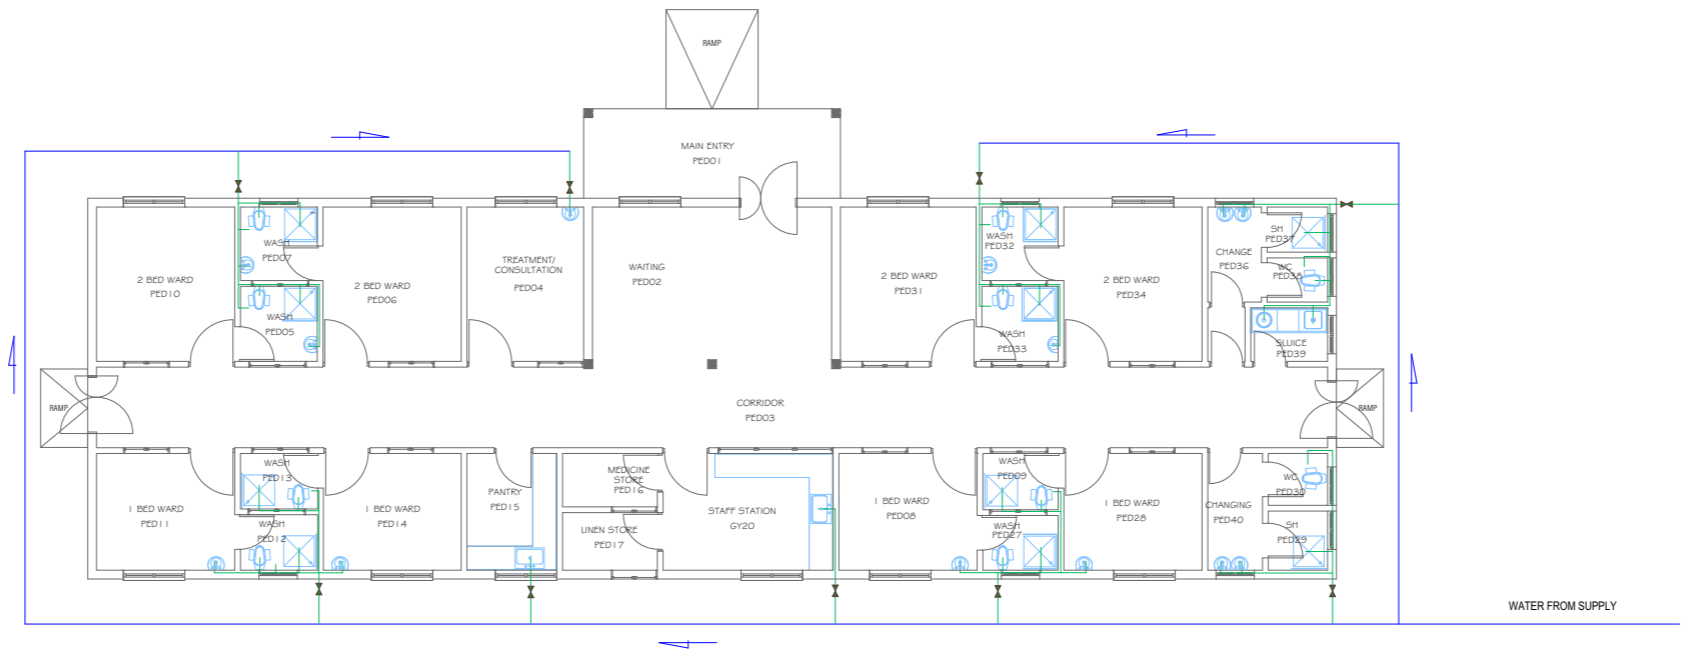

FLOOR PLAN

<p>Building Section Planning and Policy Department Ministry of Health, Community Development, Gender Elderly and Children. University of Dodoma College of Humanities and Social Science 11th Building, P.O. Box 743, 40478 Dodoma</p>	<p>In Collaboration with President's Office, Regional Administration and Local Government. Mkapa Building, P.O. Box 1923, 41185 Dodoma</p>	<p>Client PRESIDENT'S OFFICE, REGIONAL ADMINISTRATION AND LOCAL GOVERNMENT, MKAPA BUILDING, P.O. BOX 1923, 41185 DODOMA</p> <p>Project STANDARD DESIGN FOR COUNCIL LEVEL HOSPITALS IN TANZANIA</p>	<p>Drawing title GRADE ONE WARD WATER LAYOUT</p> <table border="1" style="width: 100%; border-collapse: collapse;"> <tr> <td style="width: 50%;">Project number</td> <td rowspan="4" style="text-align: center; vertical-align: middle;">GOW/W101</td> </tr> <tr> <td>Date</td> <td style="text-align: center;">May, 2018</td> </tr> <tr> <td>Drawn by</td> <td style="text-align: center;">AAI</td> </tr> <tr> <td>Checked by</td> <td style="text-align: center;">ACJ</td> </tr> <tr> <td colspan="2" style="text-align: right;">Scale</td> <td style="text-align: center;">1:150</td> </tr> </table>	Project number	GOW/W101	Date	May, 2018	Drawn by	AAI	Checked by	ACJ	Scale		1:150
Project number	GOW/W101													
Date		May, 2018												
Drawn by		AAI												
Checked by		ACJ												
Scale		1:150												