


KEY

- IPS PIPE
- POLY PIPE
- ◀▶ CONTROL VALVE

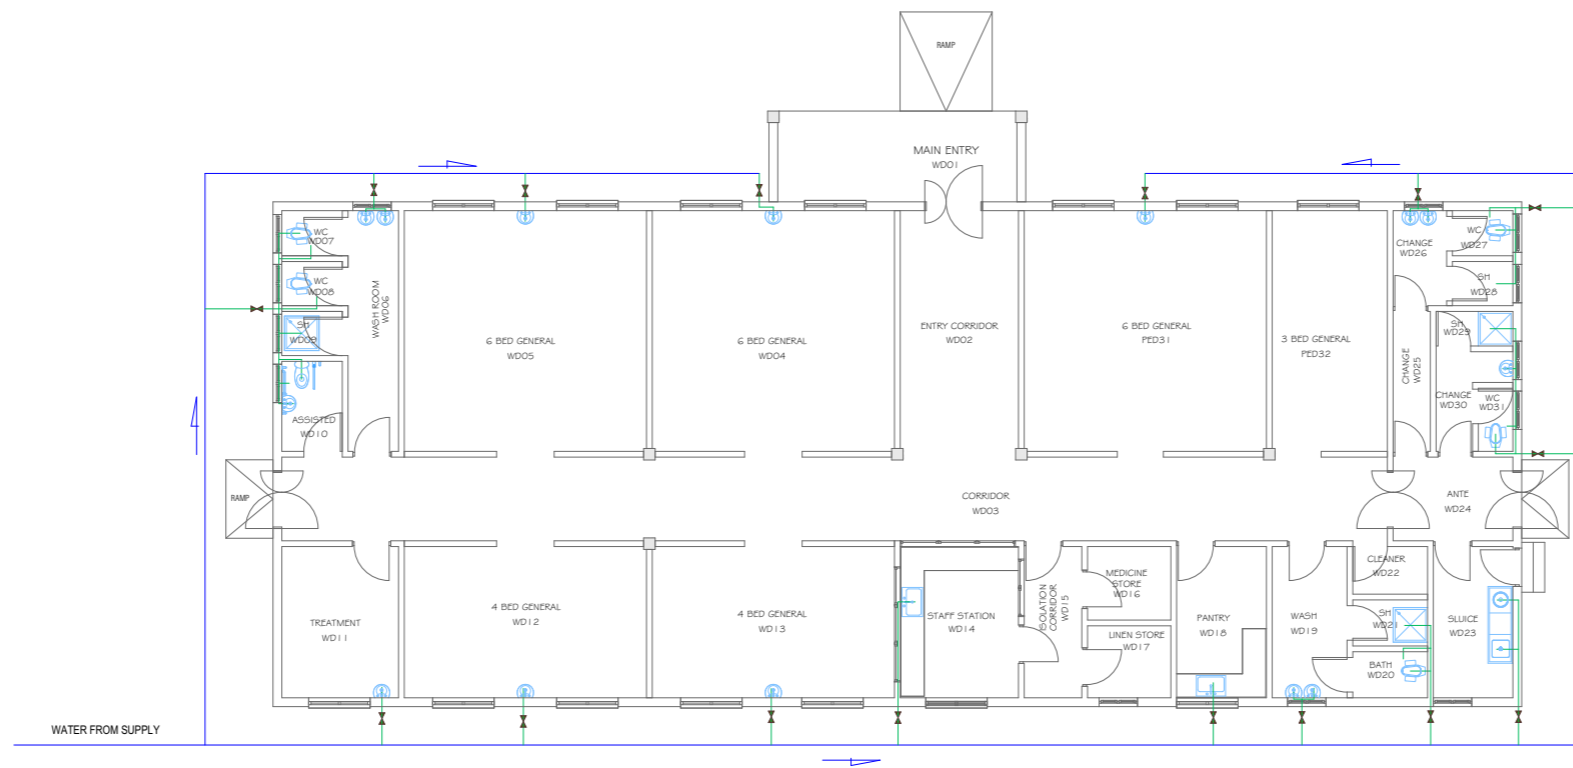

FLOOR PLAN

Building Section
 Planning and Policy Department
 Ministry of Health, Community Development,
 Gender Elderly and Children.
 University of Dodoma
 College of Humanities and Social Science 11th
 Building, P.O. Box 743,
 40478 Dodoma

In Collaboration with

President's Office, Regional Administration
 and Local Government.
 Mkapa Building,
 P.O. Box 1923,
 41185 Dodoma

Client
 PRESIDENT'S OFFICE, REGIONAL ADMINISTRATION AND
 LOCAL GOVERNMENT, MKAPA BUILDING,
 P.O. BOX 1923, 41185 DODOMA

Project
 STANDARD DESIGN FOR COUNCIL LEVEL HOSPITALS IN
 TANZANIA

Drawing title		SURGICAL & MEDICAL WARD WATER LAYOUT	
Project number		S#MW/W101	
Date	May, 2018		
Drawn by	AAI		
Checked by	ACJ		
	Scale	1:150	